


**DISHWASHER
 HW BOOSTER DETAIL**
 1
 M.S.
 NO SCALE

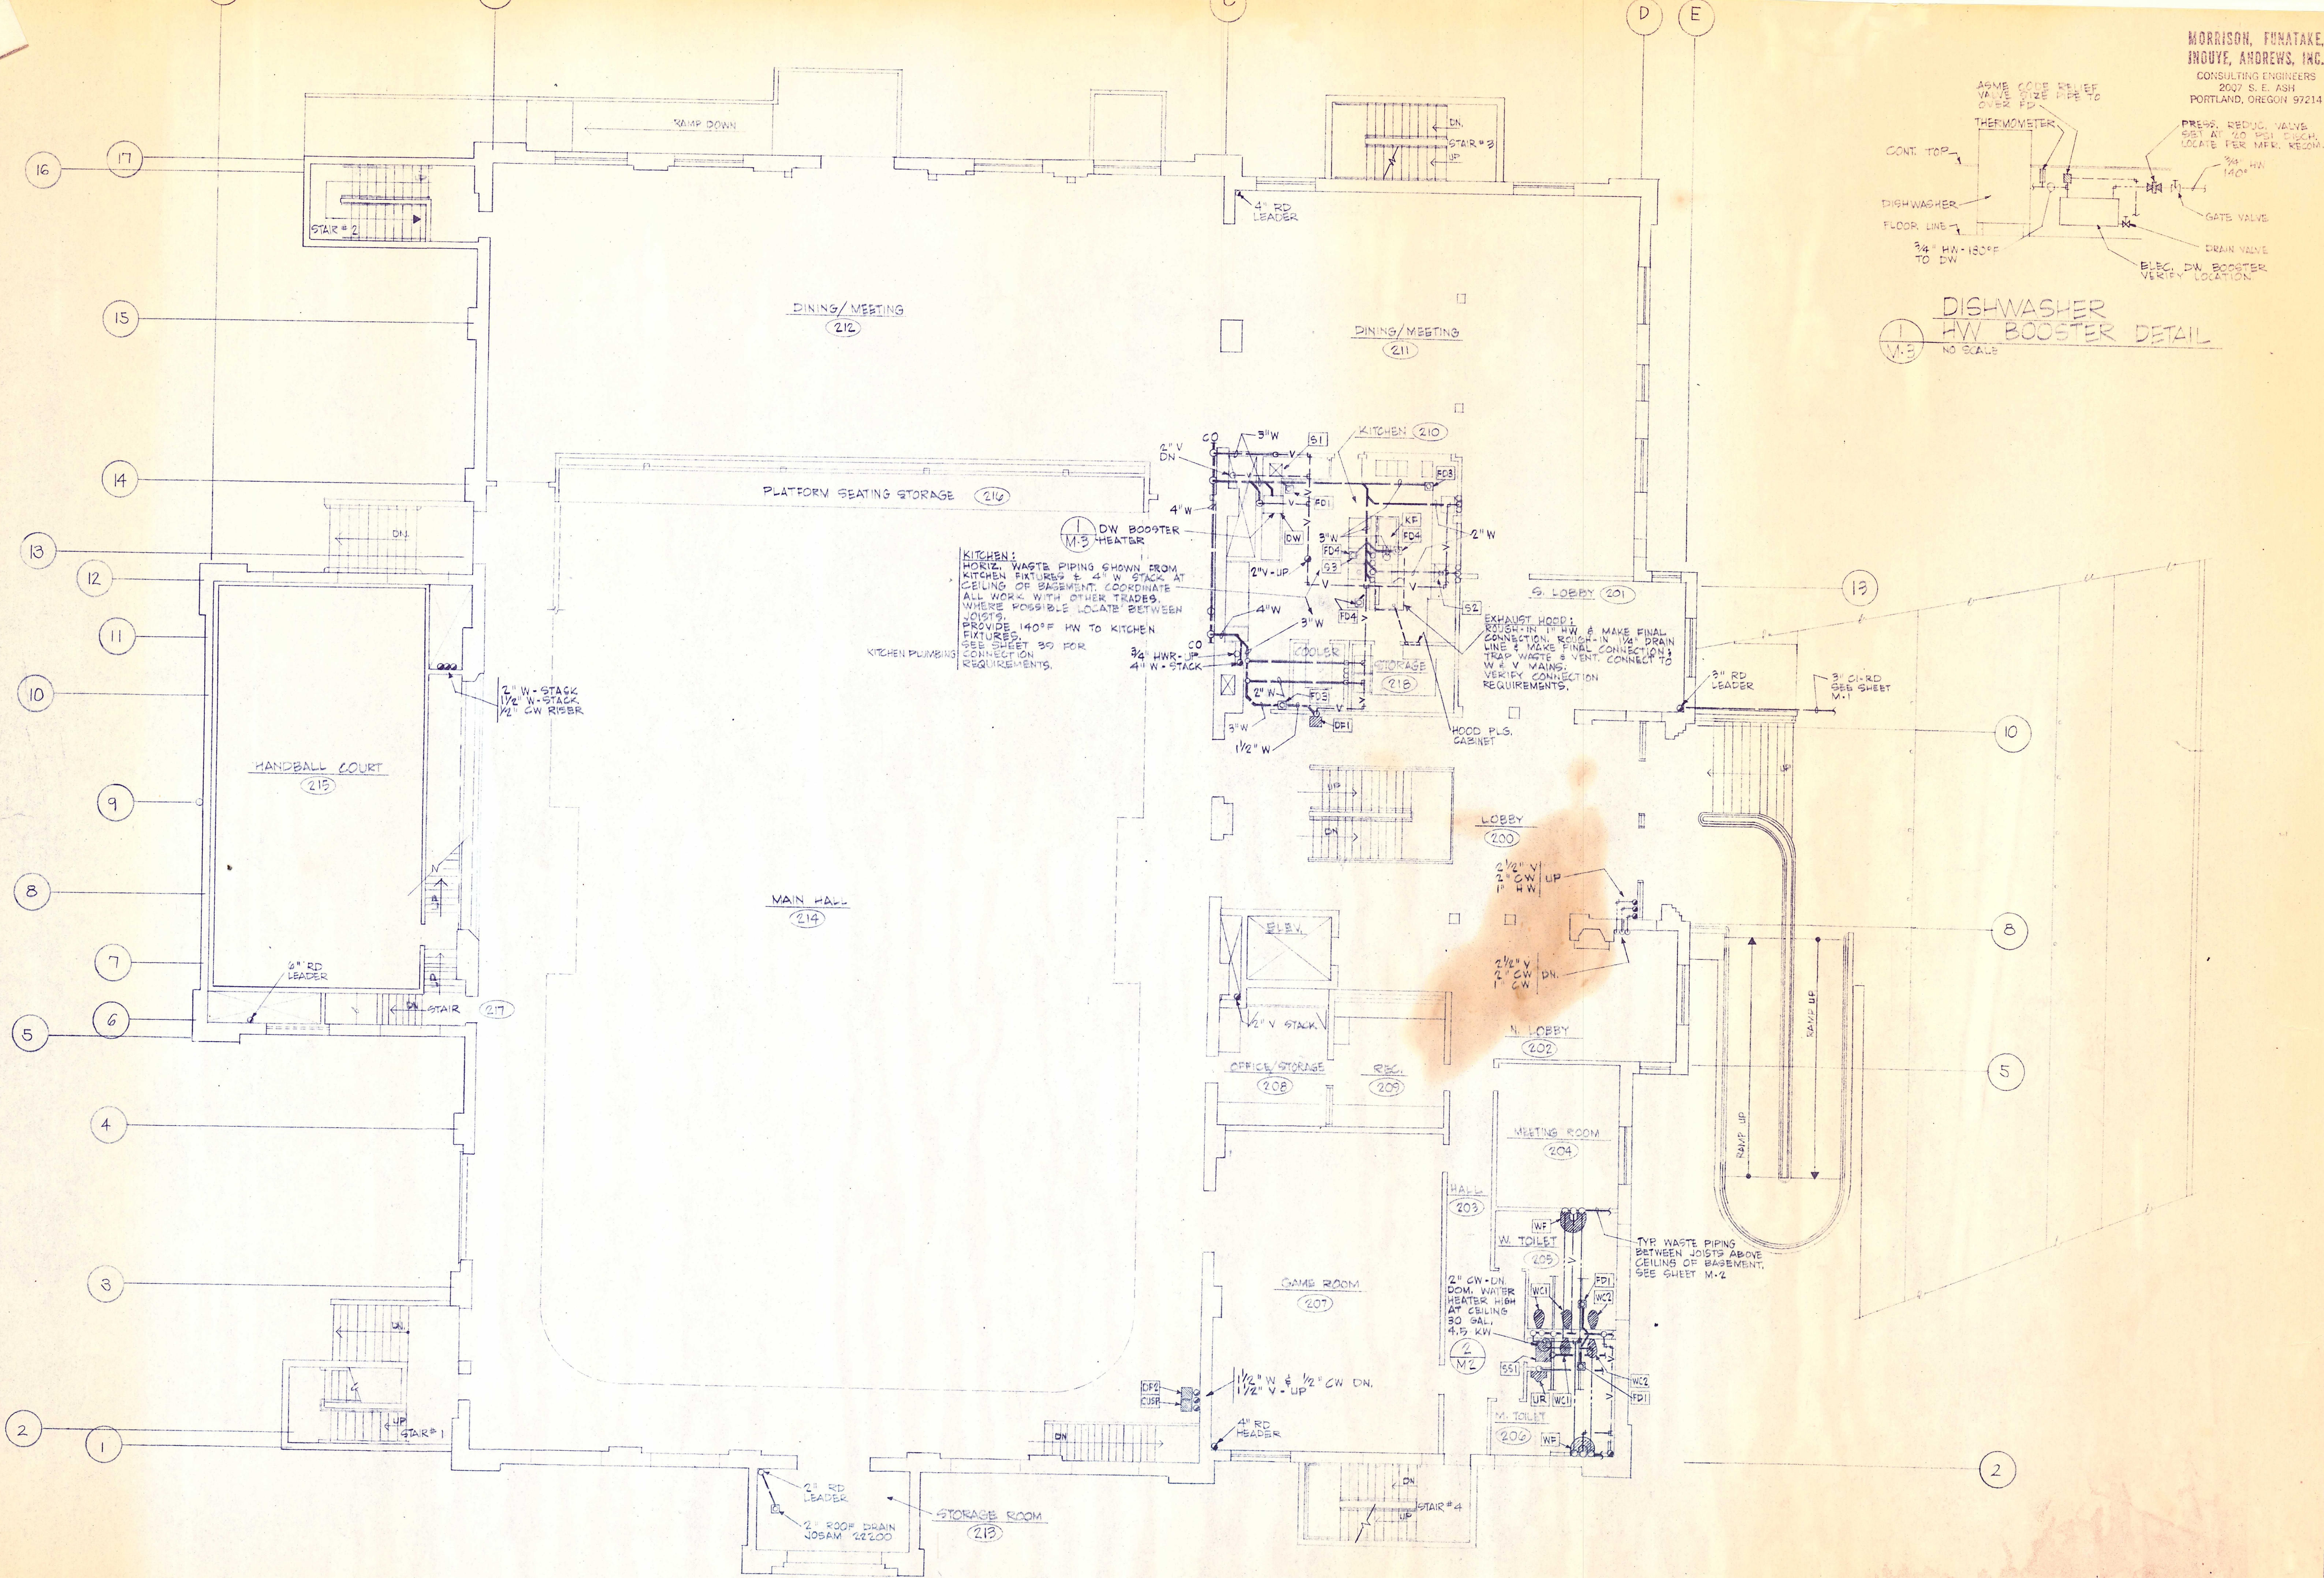

KITCHEN:
 HORIZ. WASTE PIPING SHOWN FROM
 KITCHEN FIXTURES & 4" W STACK AT
 CEILING OF BASEMENT. COORDINATE
 ALL WORK WITH OTHER TRADES.
 WHERE POSSIBLE LOCATE BETWEEN
 JOISTS.
 PROVIDE 140°F HW TO KITCHEN
 FIXTURES.
 SEE SHEET 30 FOR
 CONNECTION
 REQUIREMENTS.

EXHAUST HOOD:
 EXHAUST IN 1" HW & MAKE FINAL
 CONNECTION. ROUGH-IN 1/4" DRAIN
 LINE & MAKE FINAL CONNECTION.
 TRAP WASTE & VENT. CONNECT TO
 W & V MAINS. VERIFY CONNECTION
 REQUIREMENTS.

KITCHEN PLUMBING:
 SEE SHEET 30 FOR
 CONNECTION
 REQUIREMENTS.


TYP. WASTE PIPING
 BETWEEN JOISTS ABOVE
 CEILING OF BASEMENT.
 SEE SHEET M-2

FIRST FLOOR PLAN - PLUMBING



REGISTERED ARCHITECT
 PETER WINKLER
 PORTLAND, OREGON
 ARCHITECTURE INTERIORS - PLUMBING
 MCKINVILLE COMMUNITY CENTER
 FIRST FLOOR PLAN - PLUMBING
 MCKINVILLE COMMUNITY CENTER
 PORTLAND, OREGON
 503-288-1000
 1015 NE 8TH AVE. SUITE 100



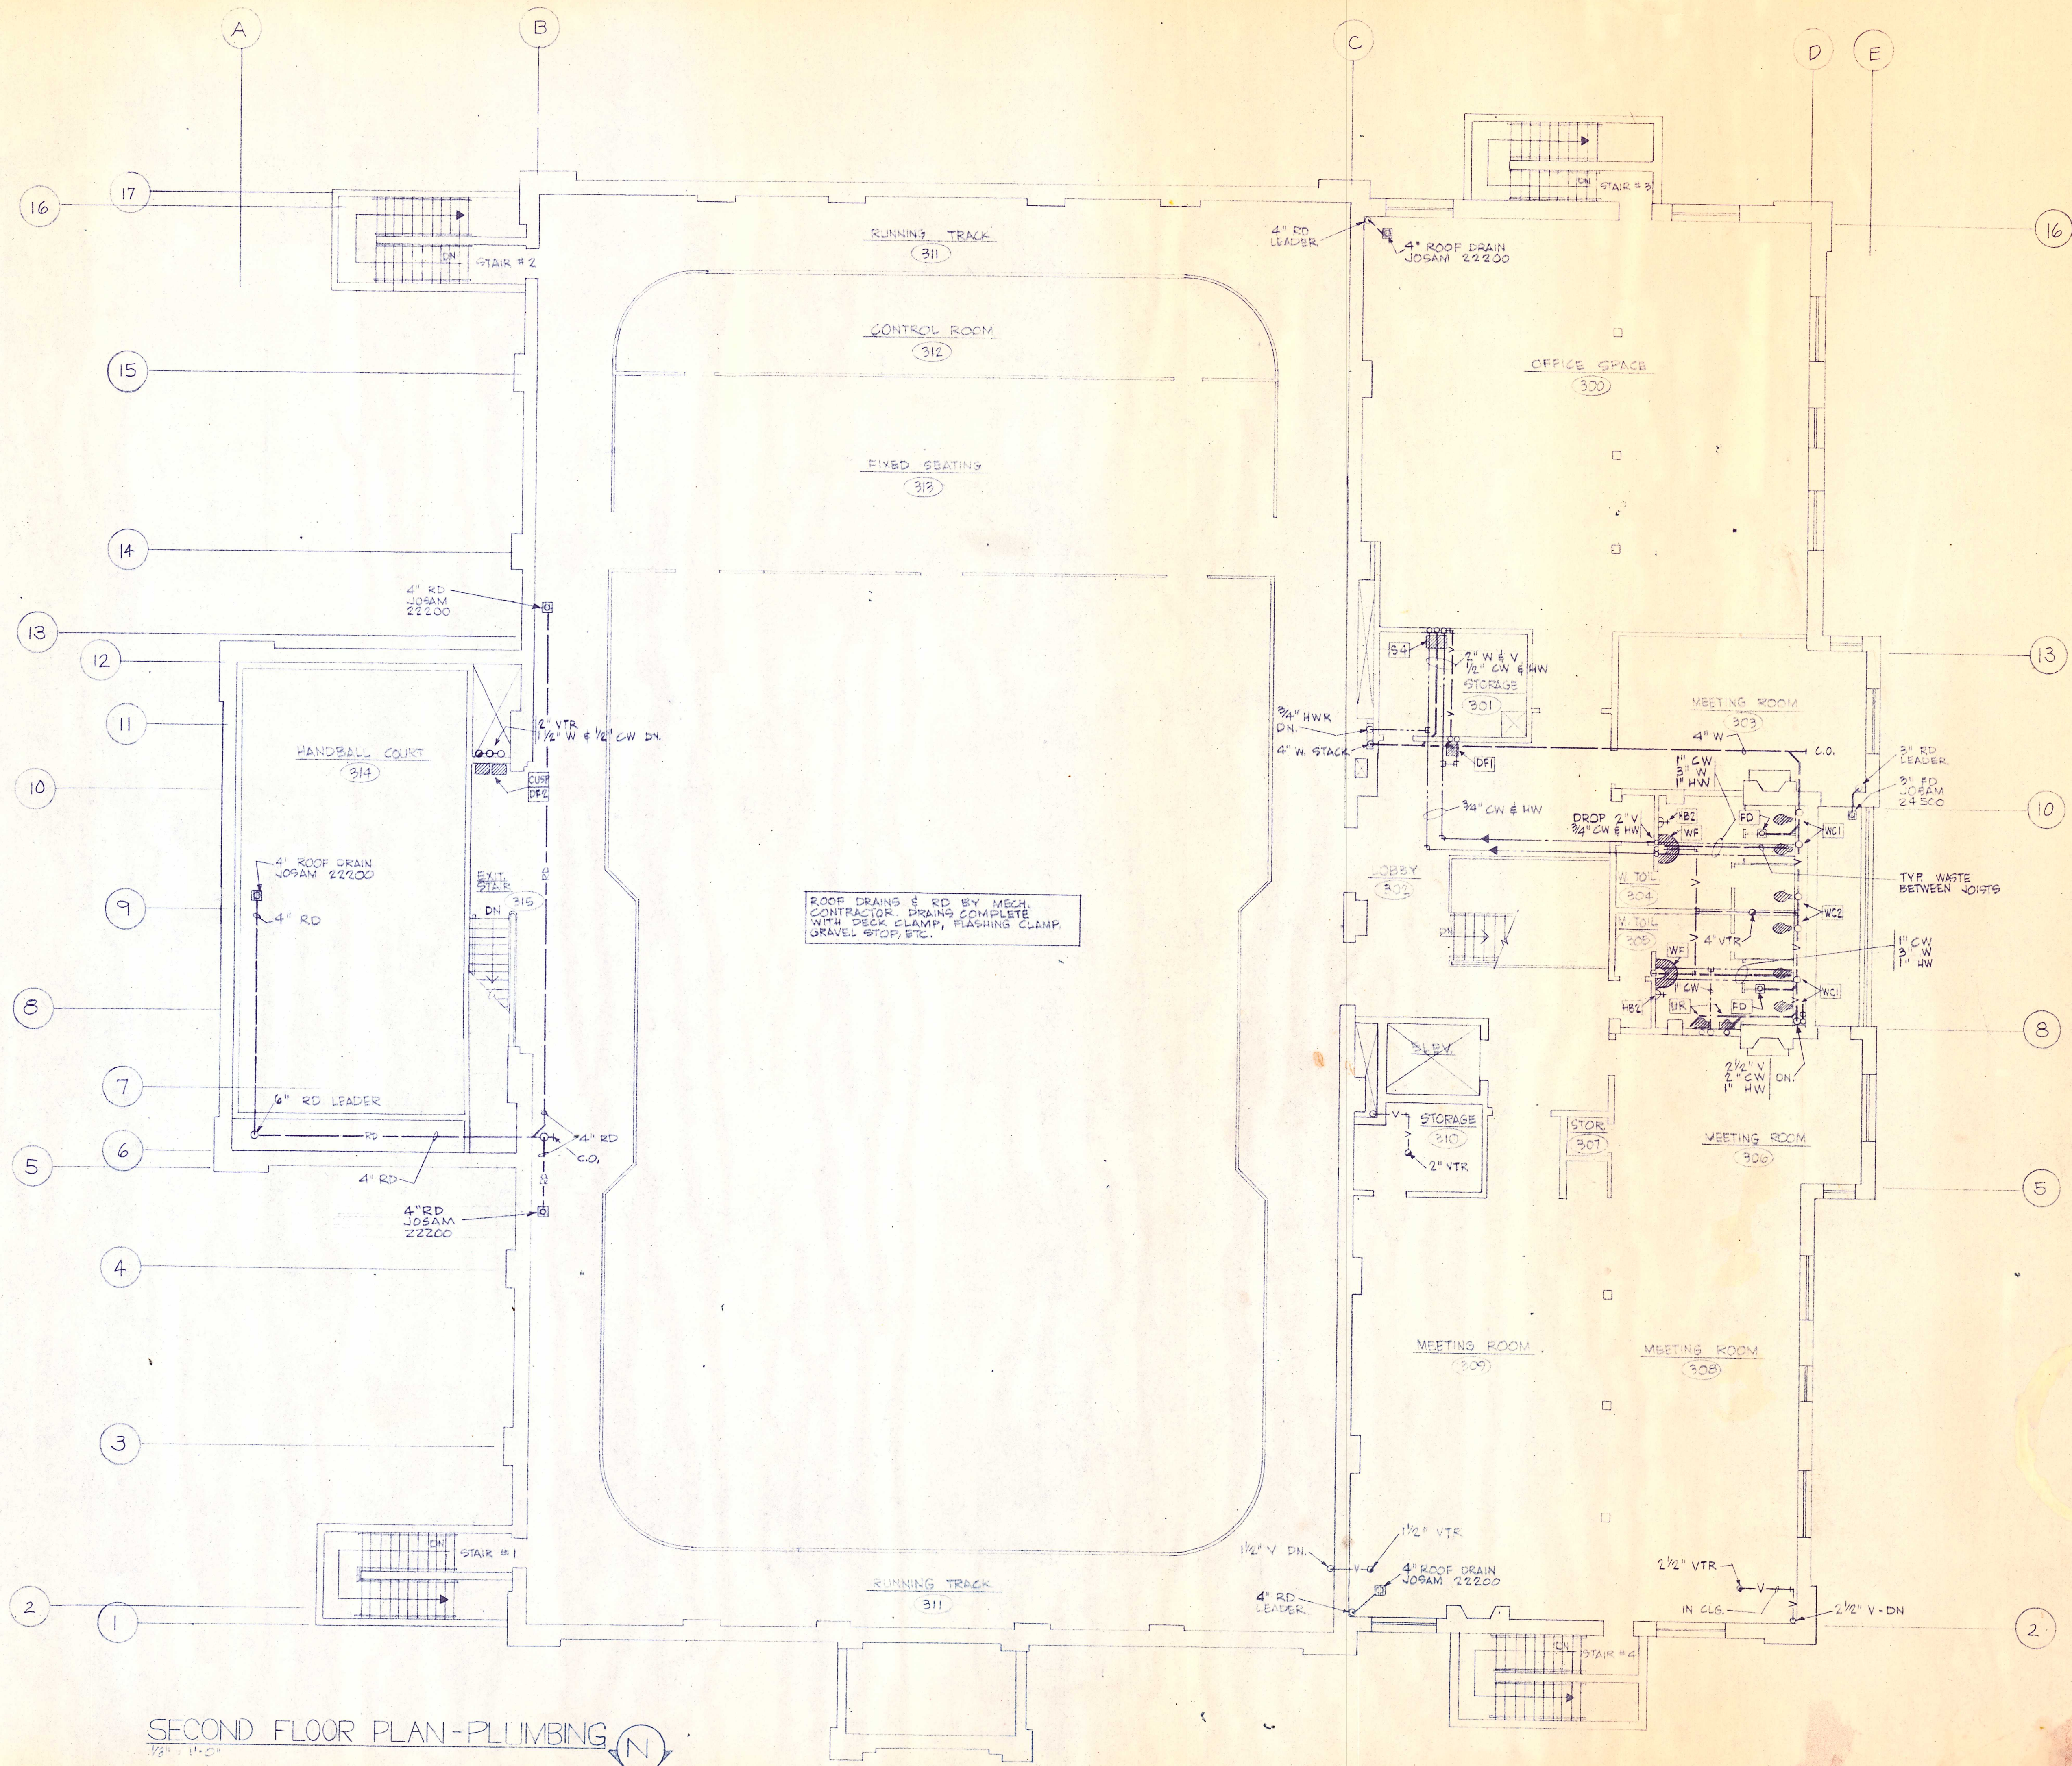

SECOND FLOOR PLAN - PLUMBING
 1/8" = 1'-0"


MORRISON, FUJITAKE,
 INGUYE, ANDREWS, INC.
 CONSULTING ENGINEERS
 2207 S.E. ASH
 PORTLAND, OREGON 97214




WINKLER ASSOCIATES AND ARCHITECTS
 1000 SW 10TH AVENUE, SUITE 1000
 PORTLAND, OREGON 97204
 PHONE: 503-241-1111
 FAX: 503-241-1112
 WWW.WINKLERARCHITECTS.COM

MCKINVILLE COMMUNITY CENTER
 SECOND FLOOR PLAN
 PLUMBING




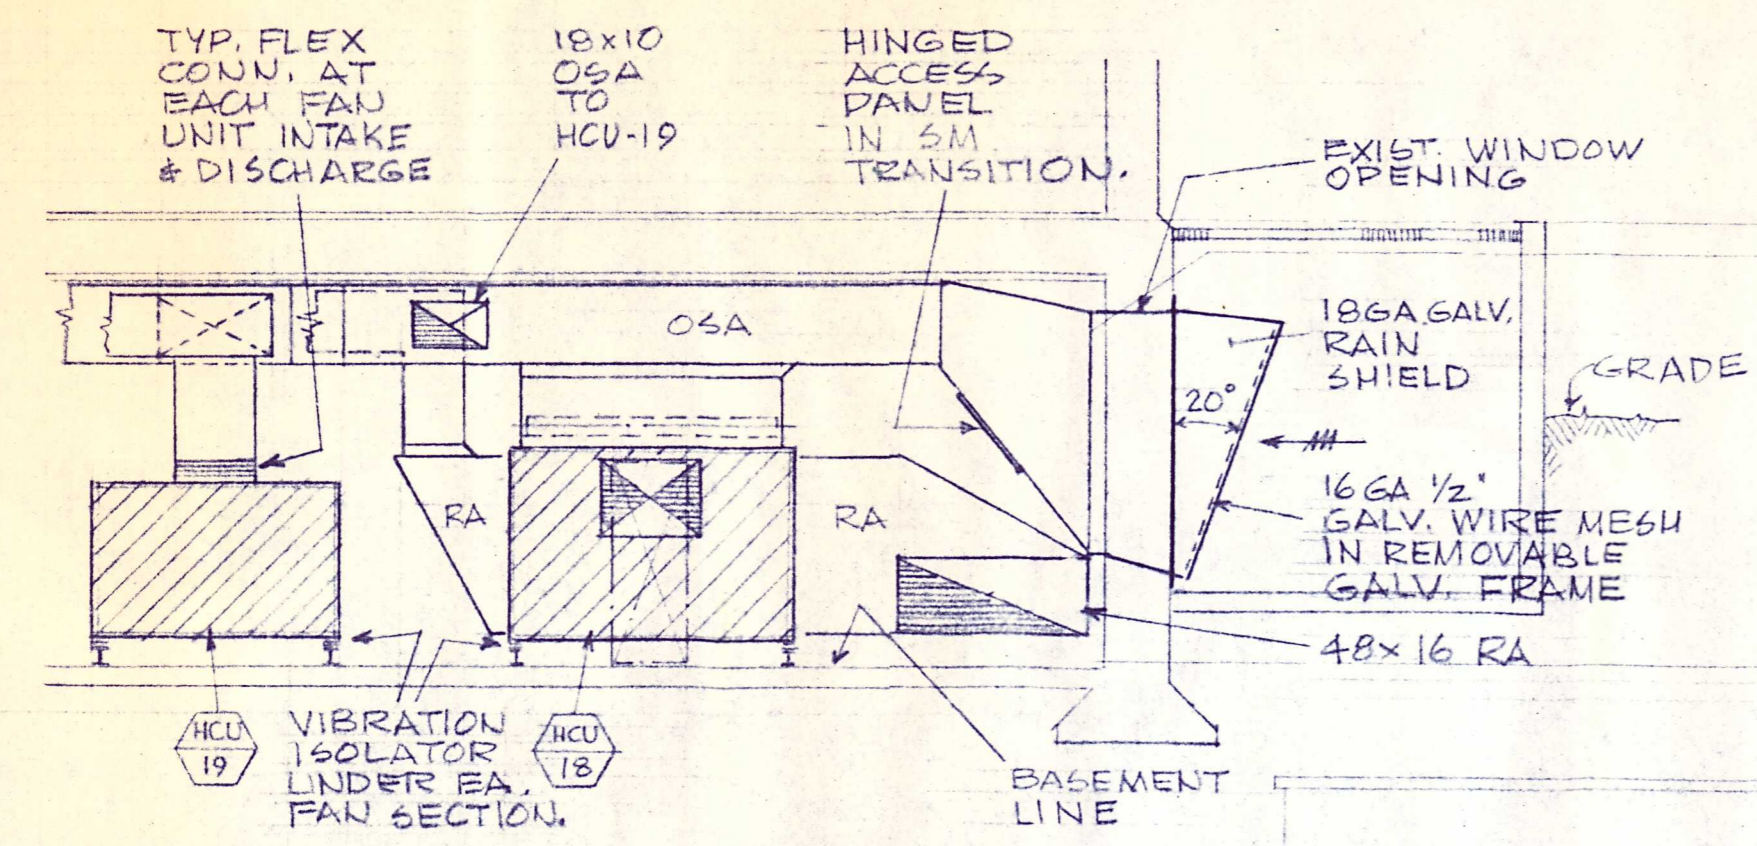



SECTION B
SCALE: 1/4" = 1'-0" M5

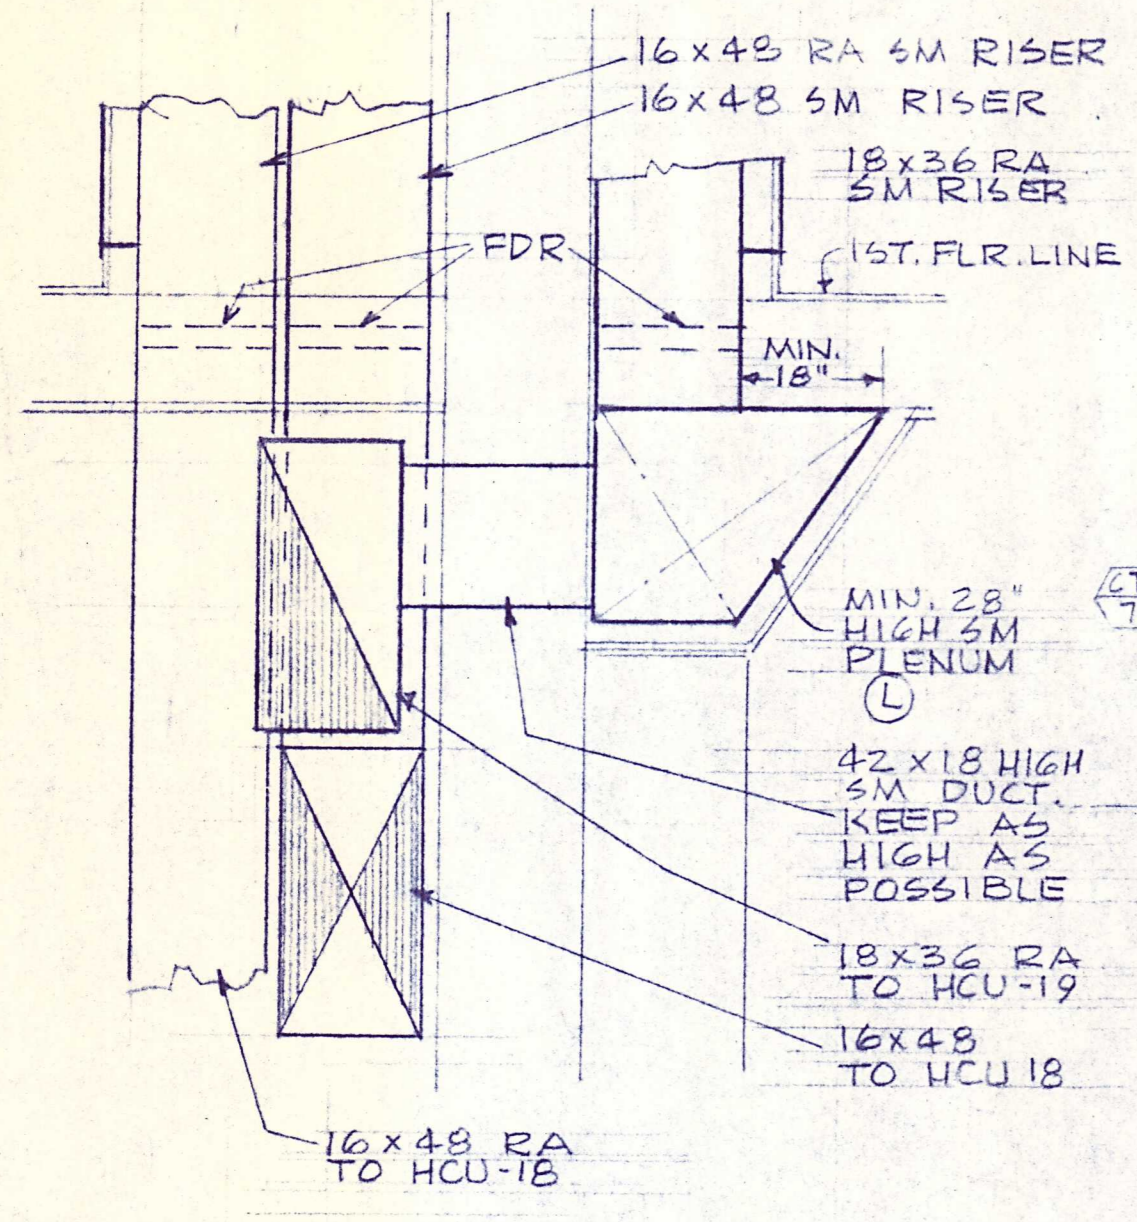


SECTION D
SCALE: 1/4" = 1'-0" M5

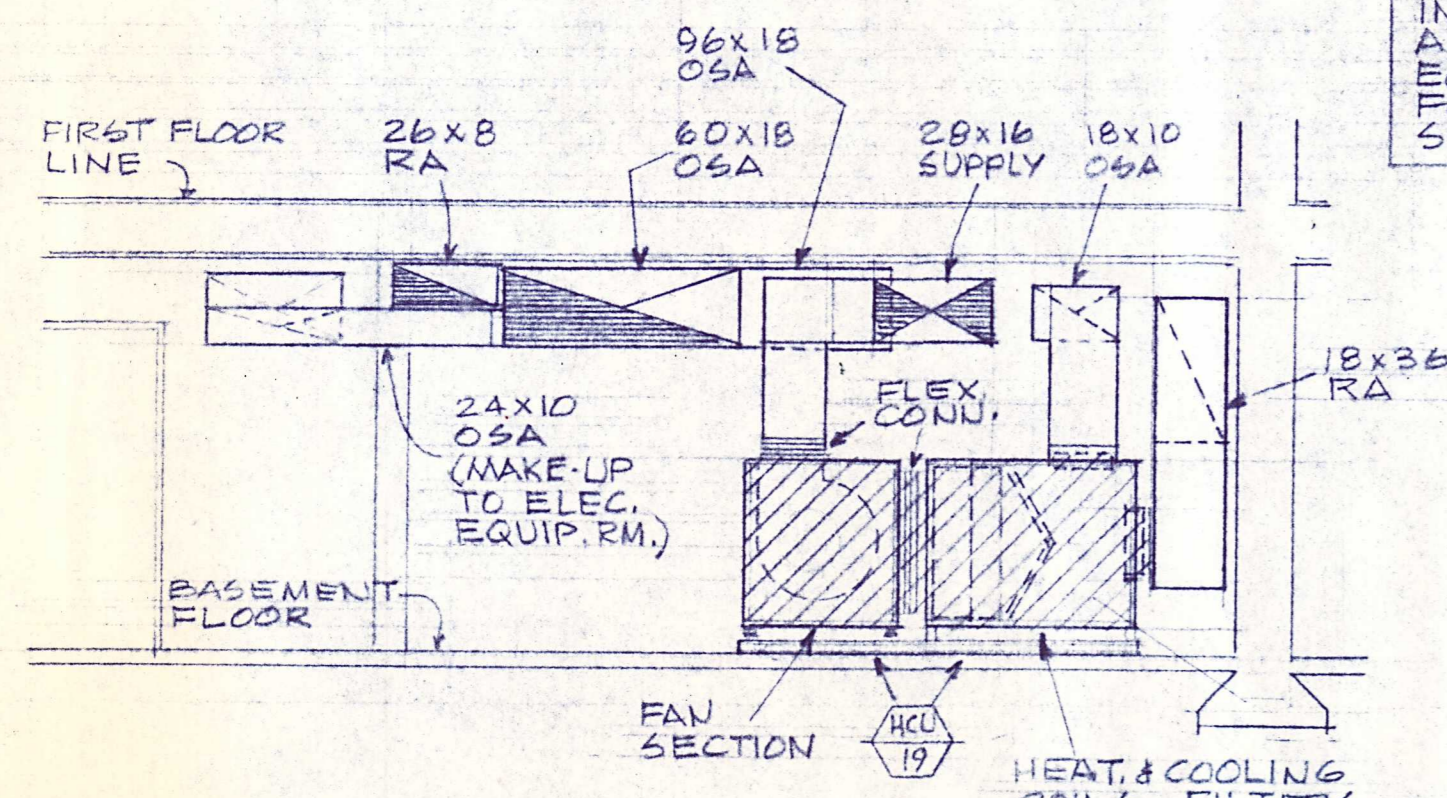

SECTION C
SCALE: 1/4" = 1'-0" M5


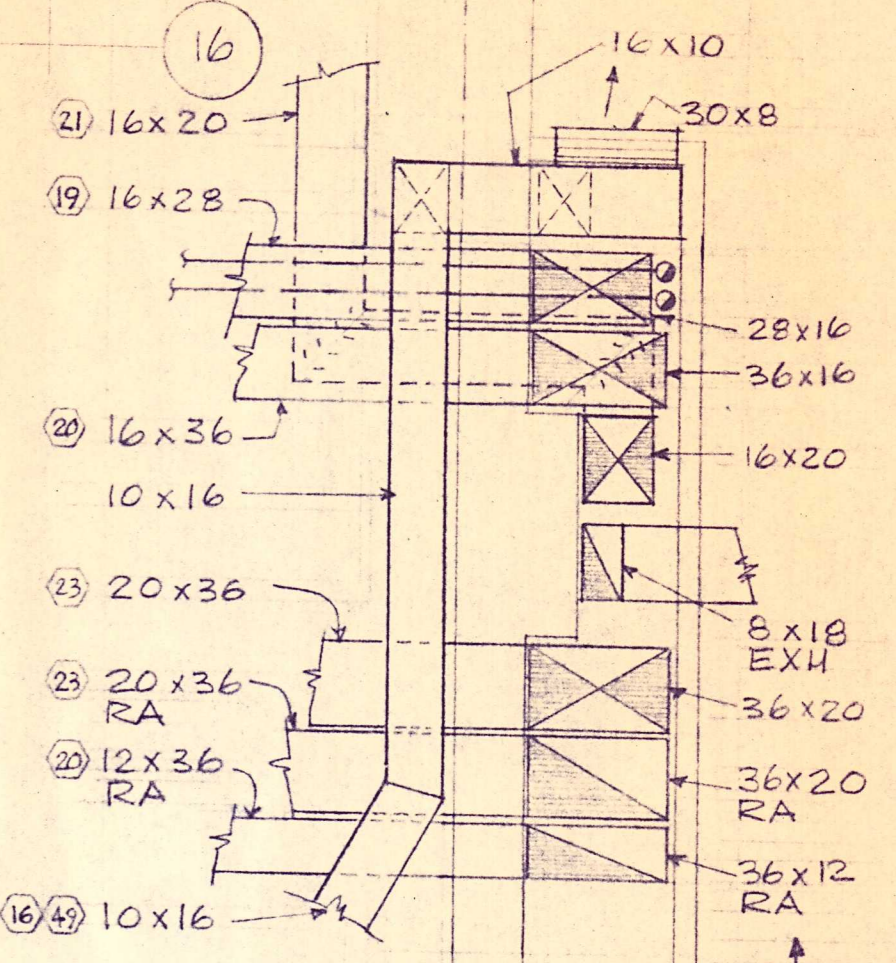
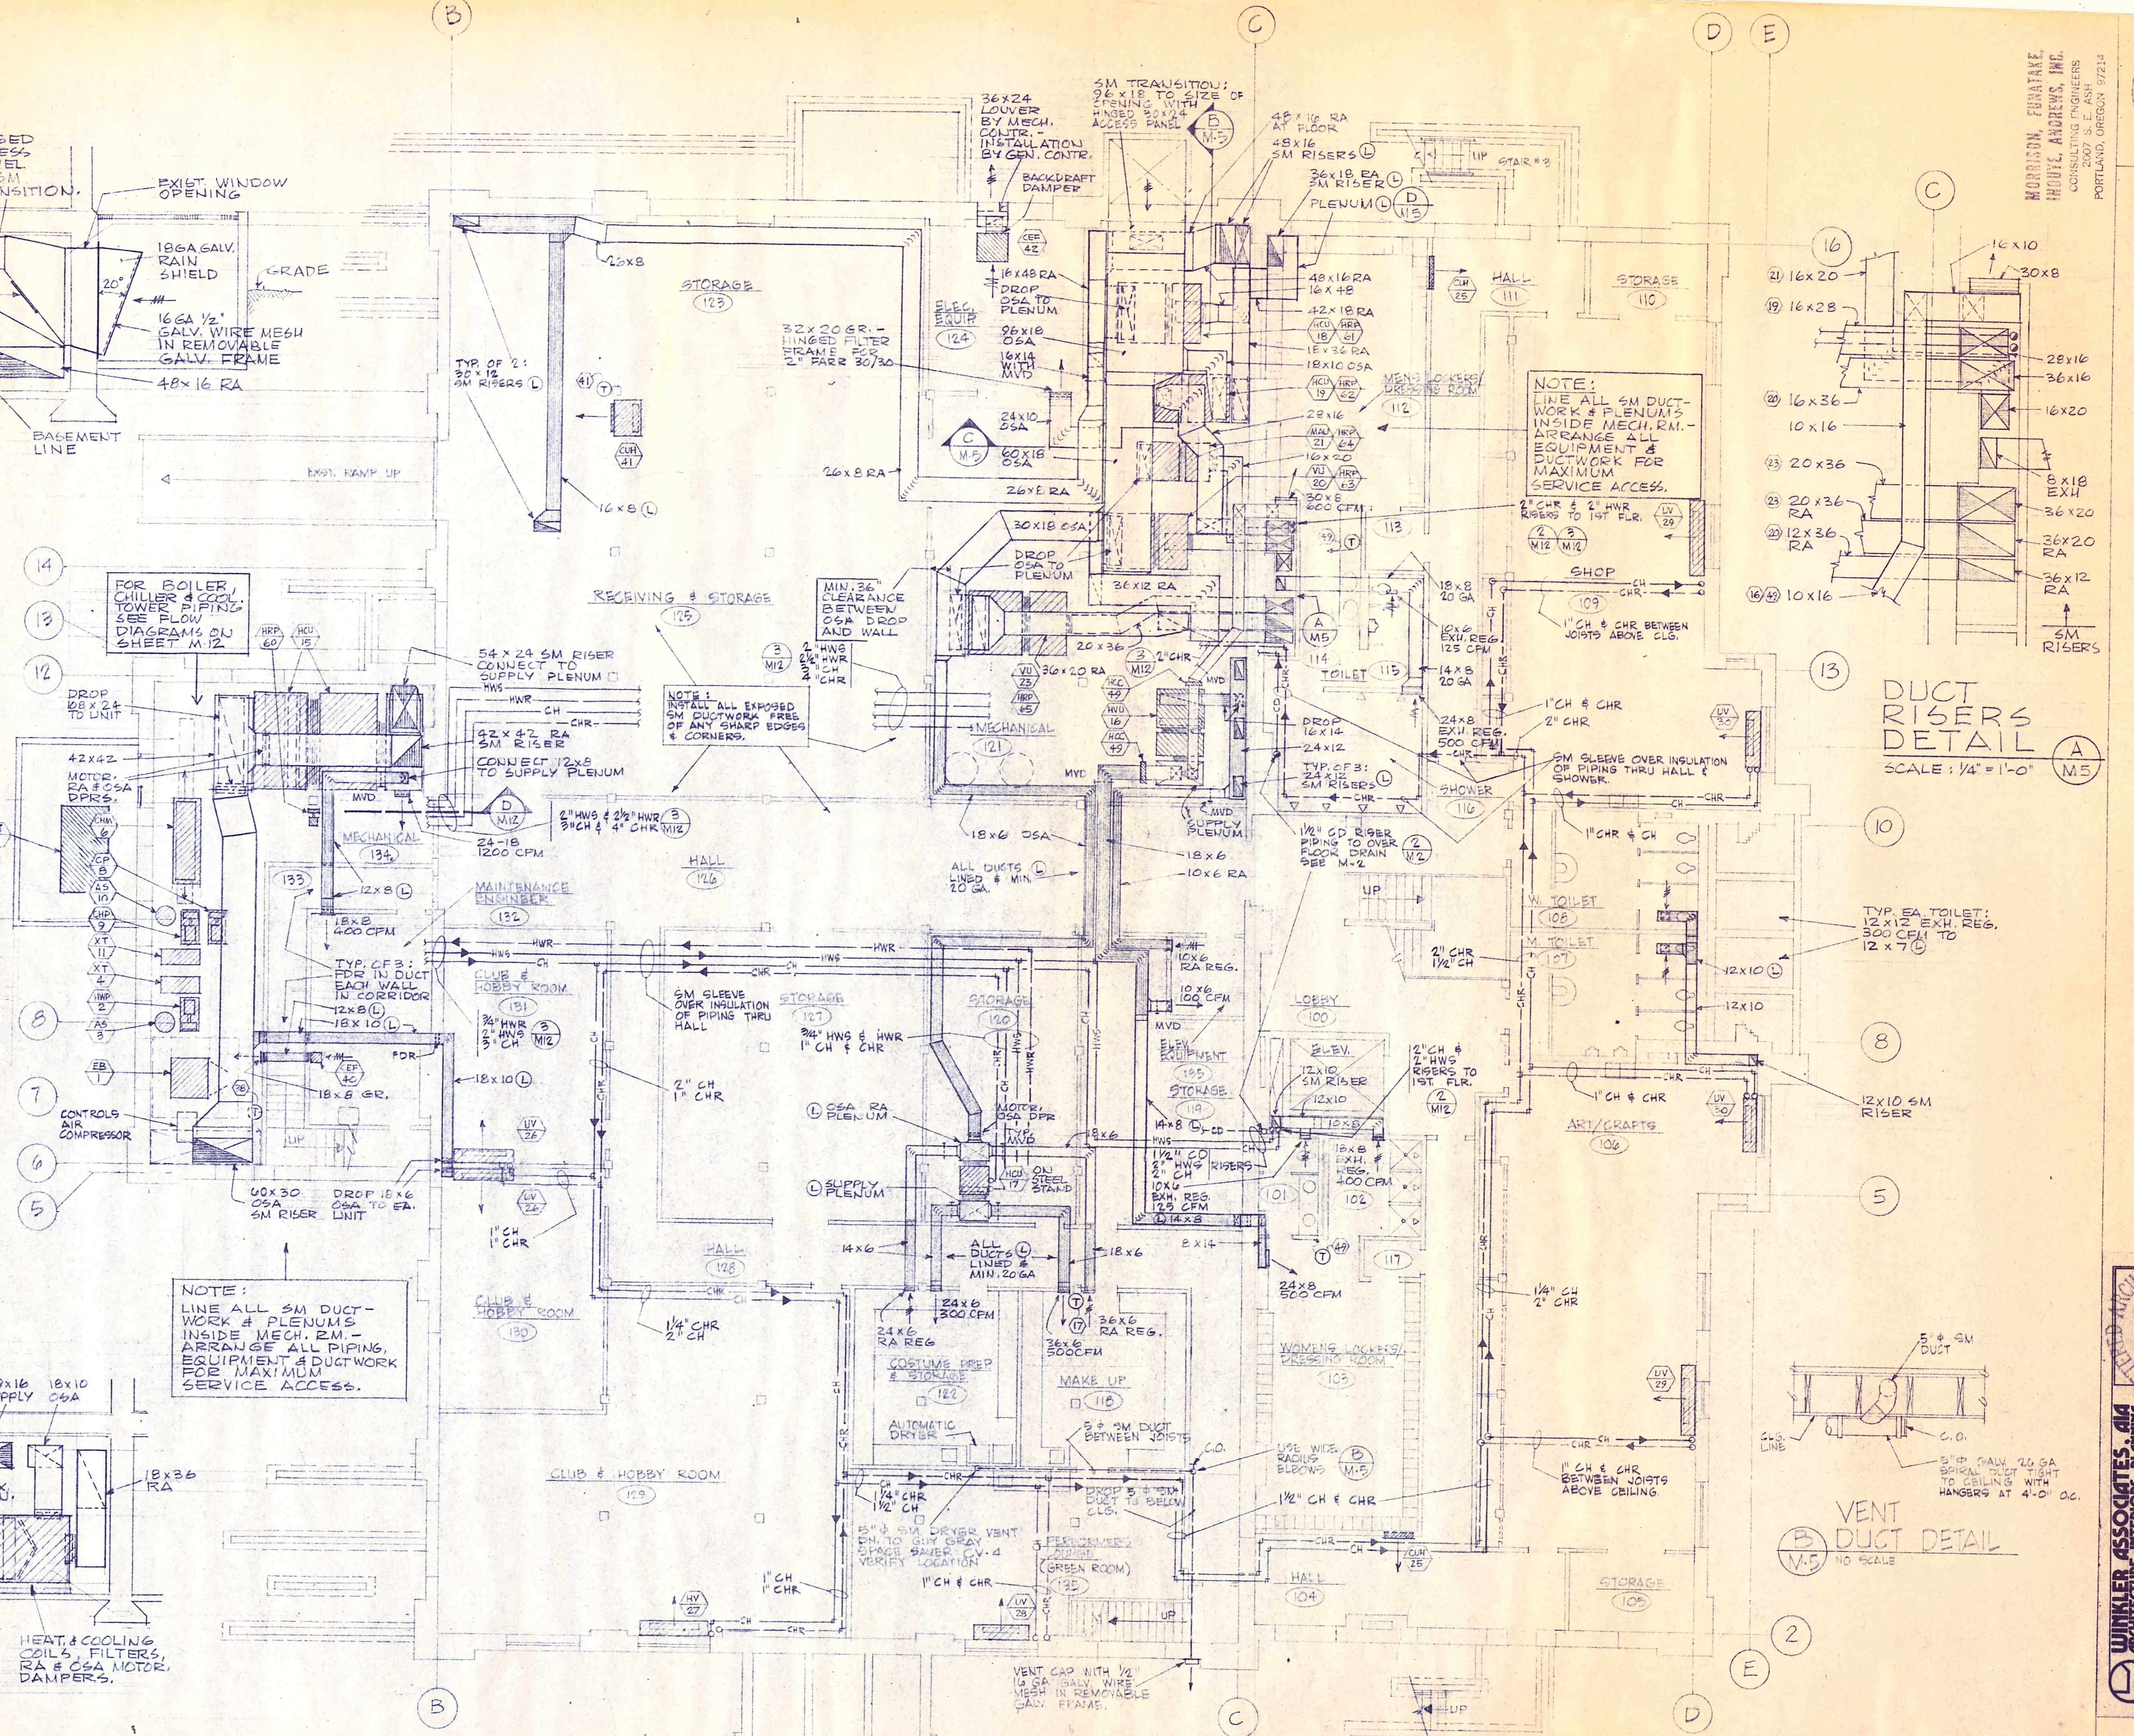


DUCT RISERS DETAIL A
SCALE: 1/4" = 1'-0" M5

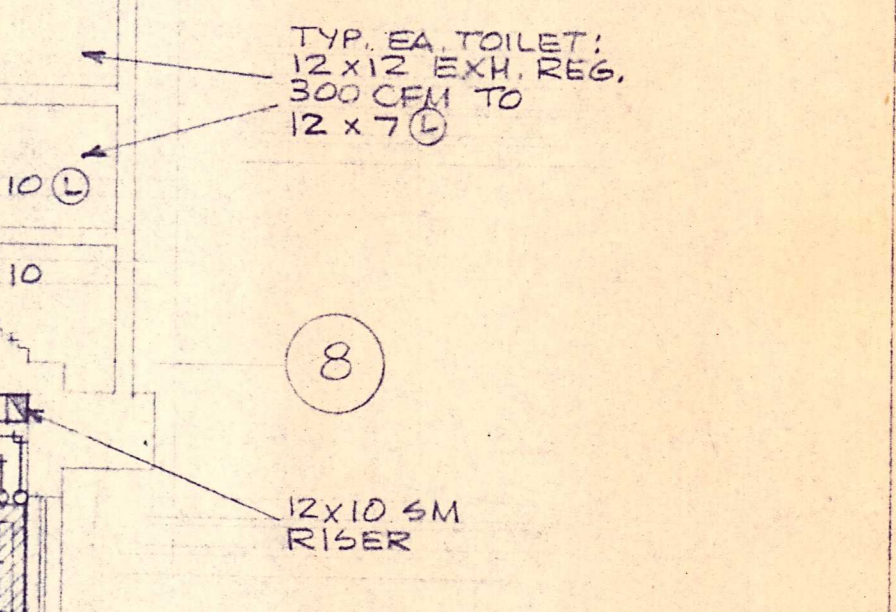


VENT DUCT DETAIL B
NO SCALE

HVAC - BASEMENT PLAN
SCALE: 1/8" = 1'-0" N

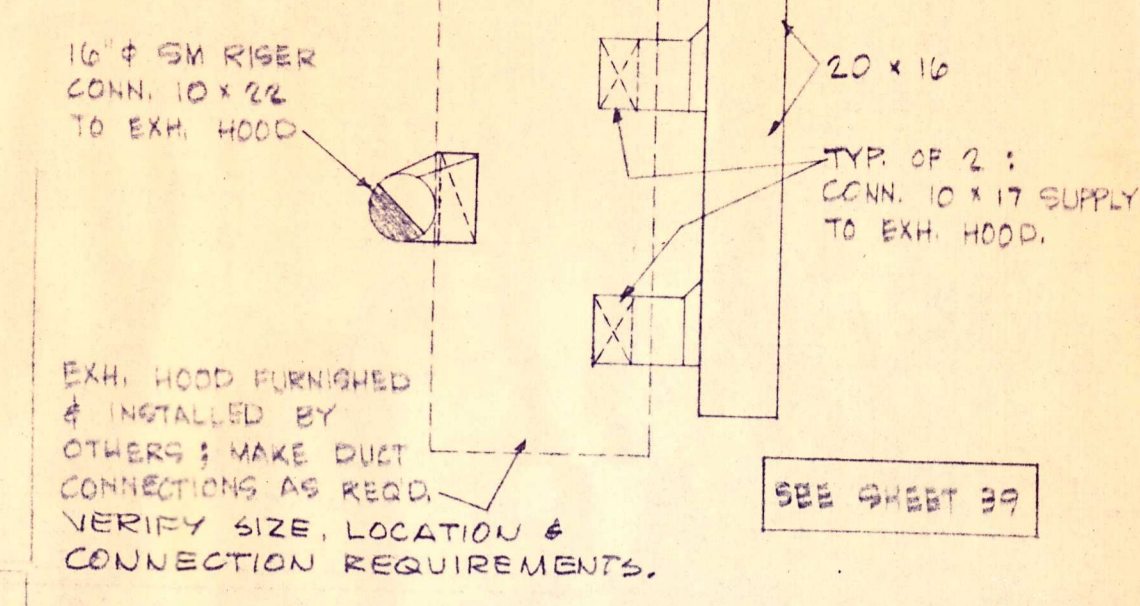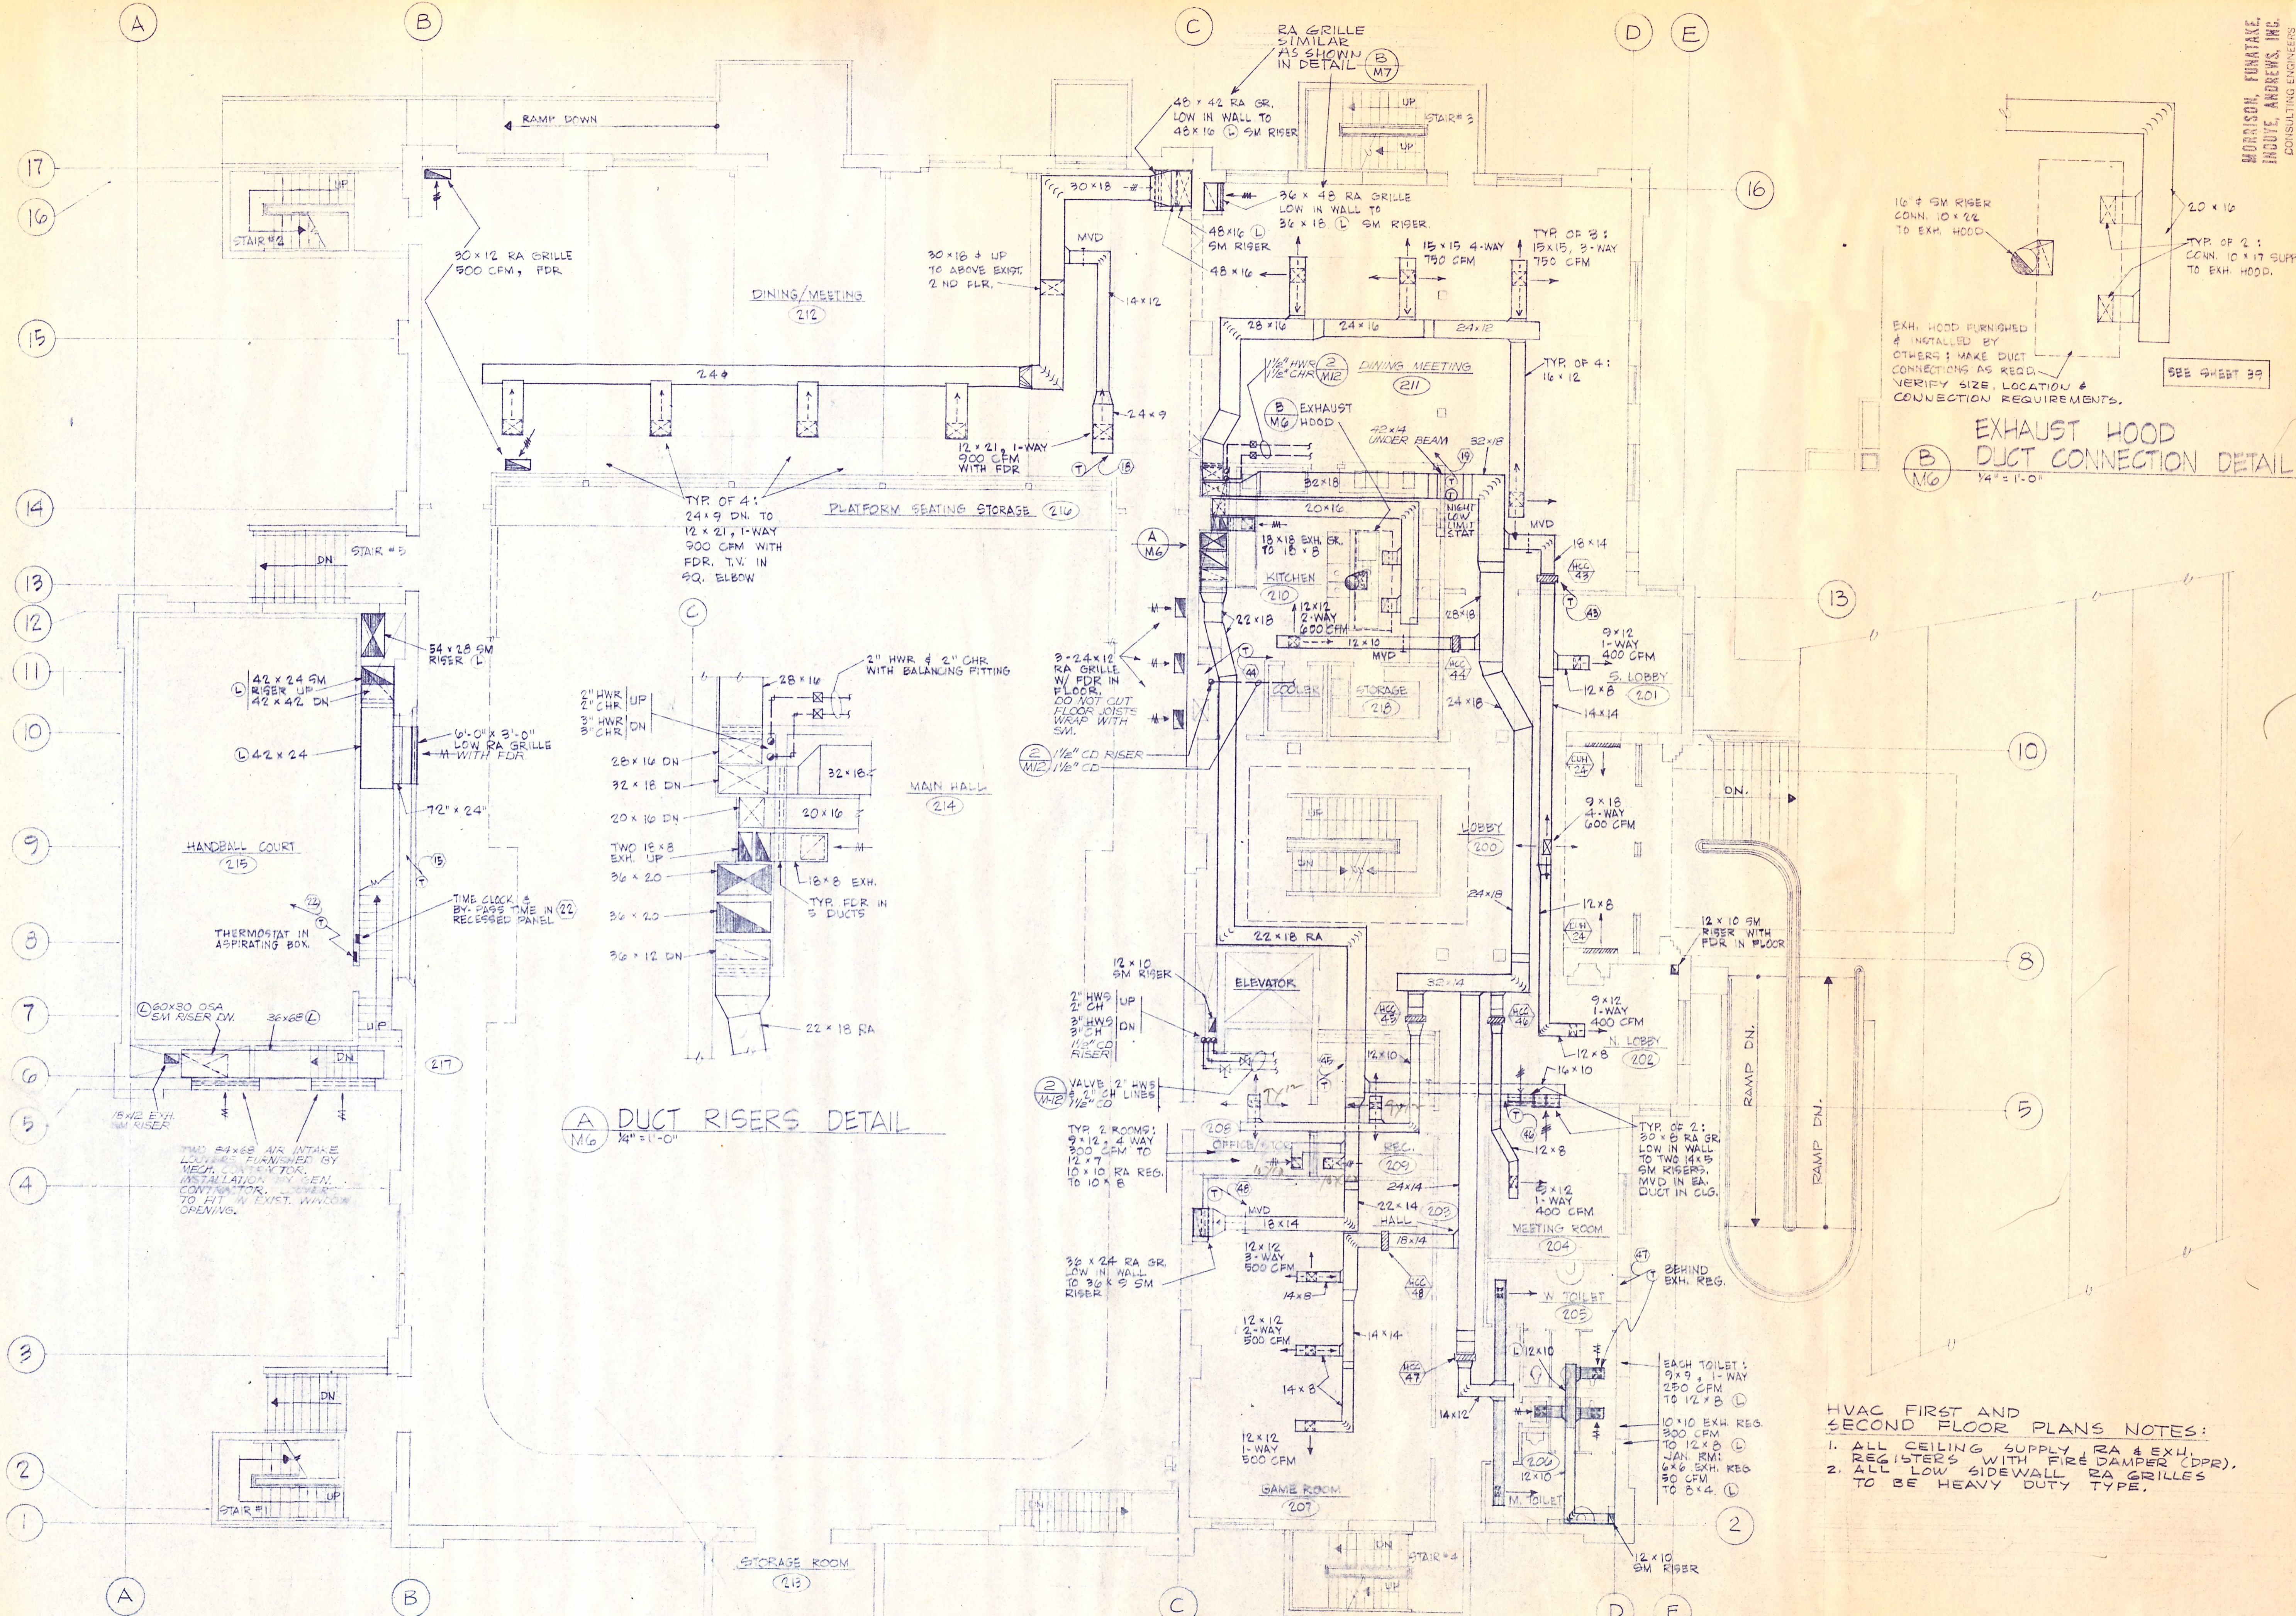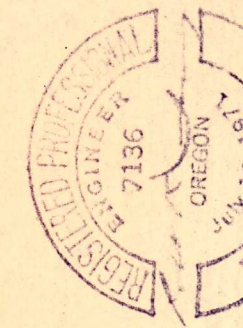





EXHAUST HOOD
 DUCT CONNECTION DETAIL
 1/4" = 1'-0"

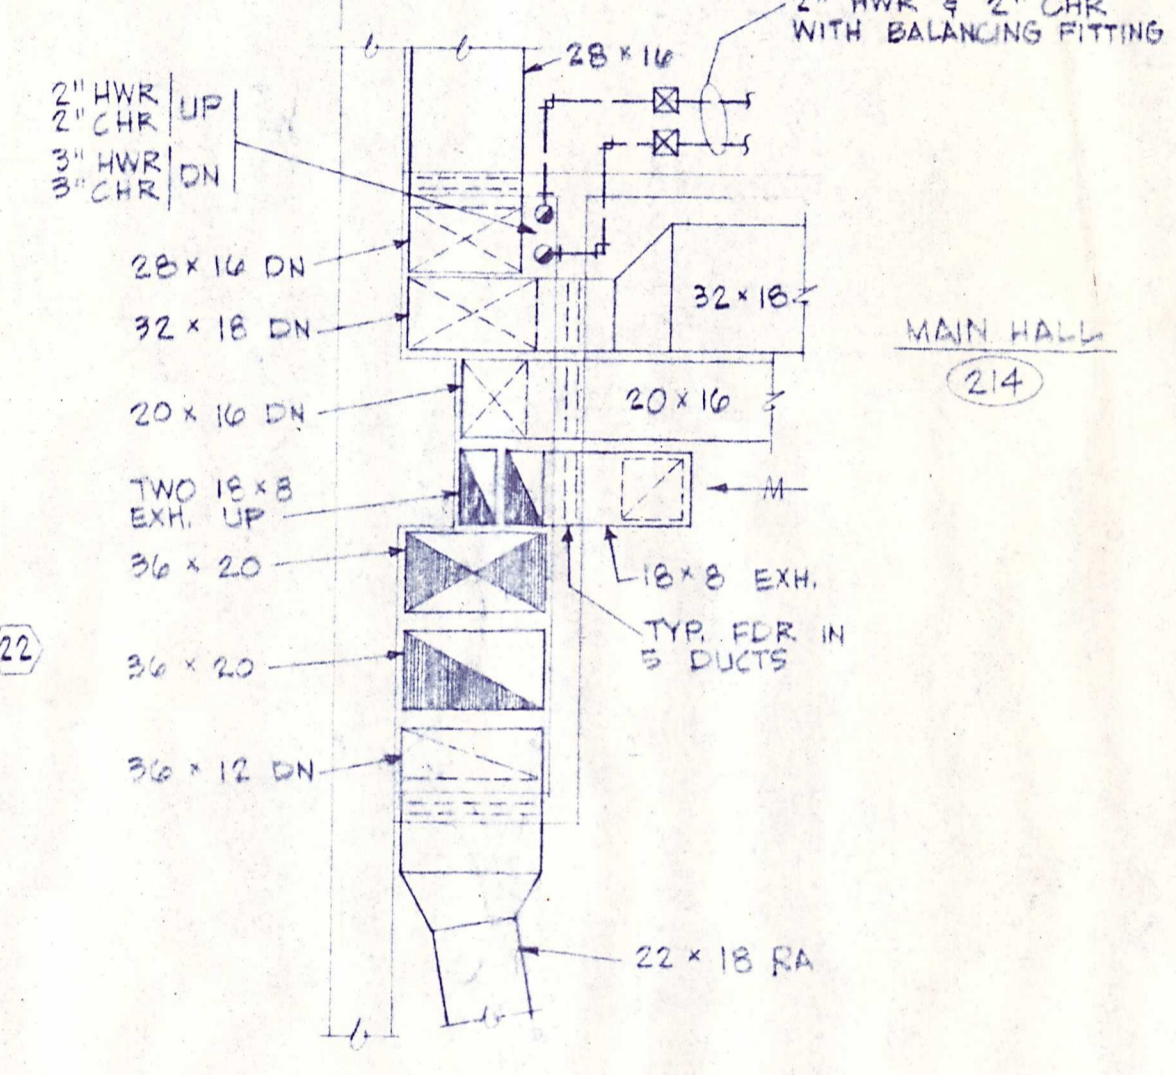


DUCT RISERS DETAIL
 1/4" = 1'-0"

- HVAC FIRST AND SECOND FLOOR PLANS NOTES:
1. ALL CEILING SUPPLY RA & EXH. REGISTERS WITH FIRE DAMPER (DPR).
 2. ALL LOW SIDEWALL RA GRILLES TO BE HEAVY DUTY TYPE.

HVAC - FIRST FLOOR PLAN
 SCALE: 1/8" = 1'-0"

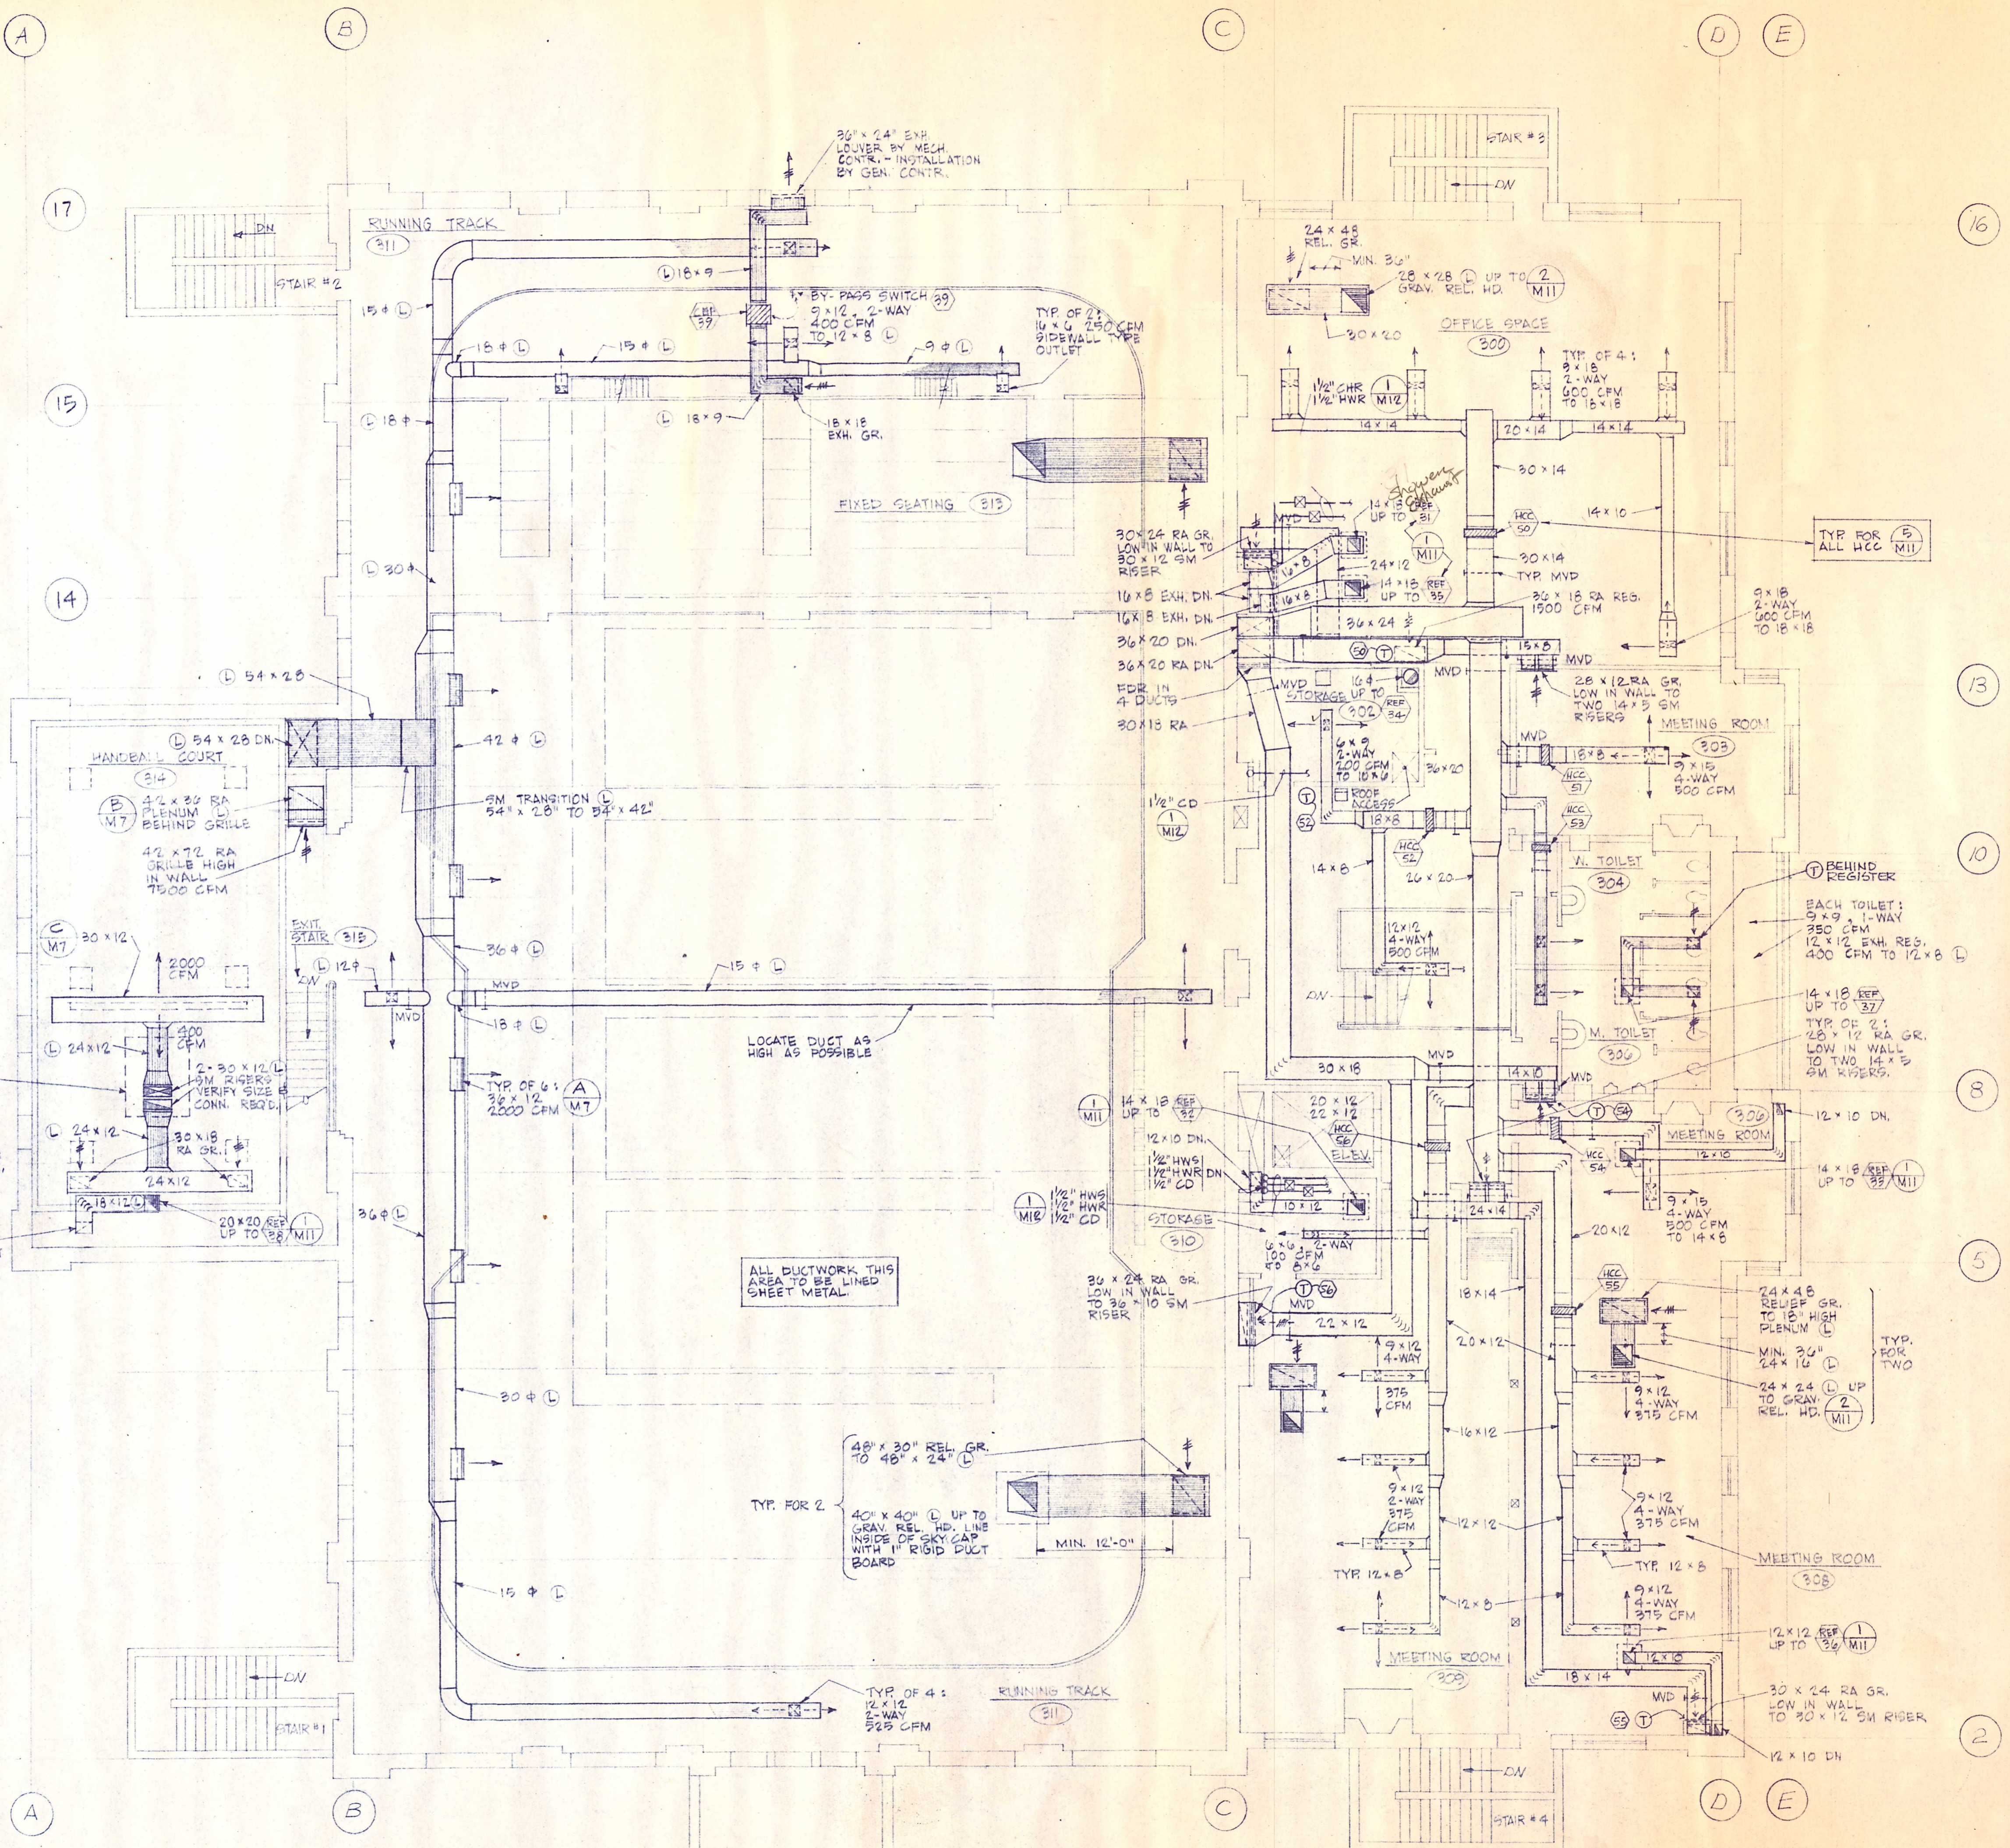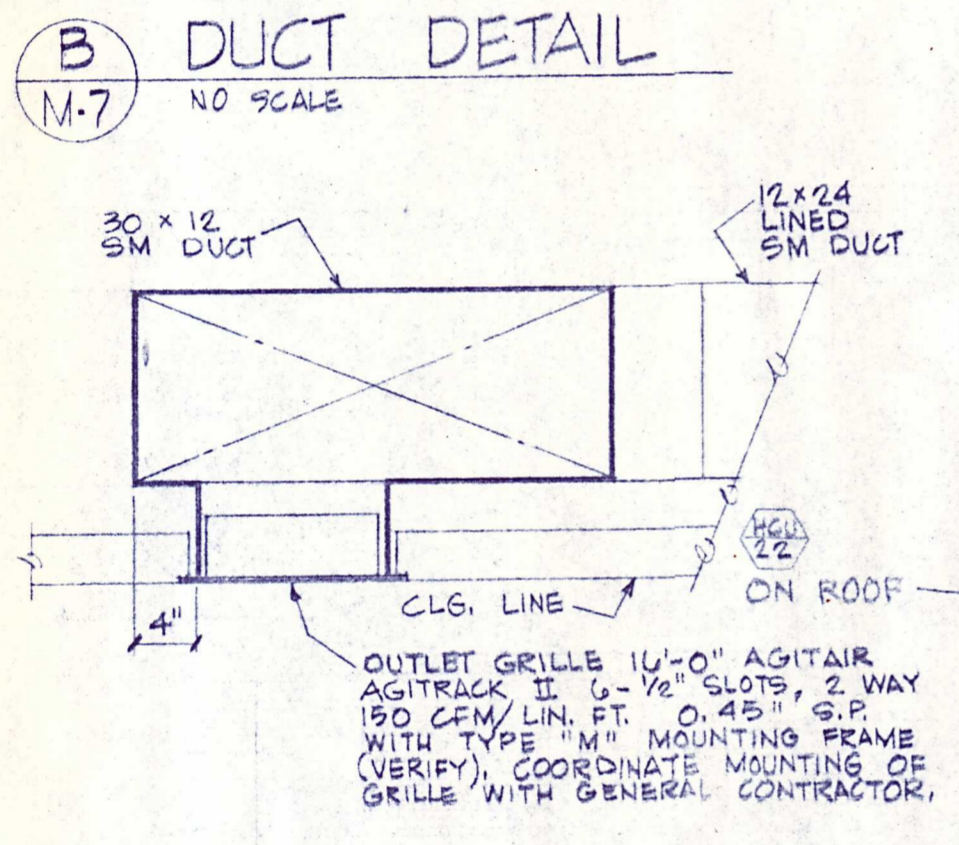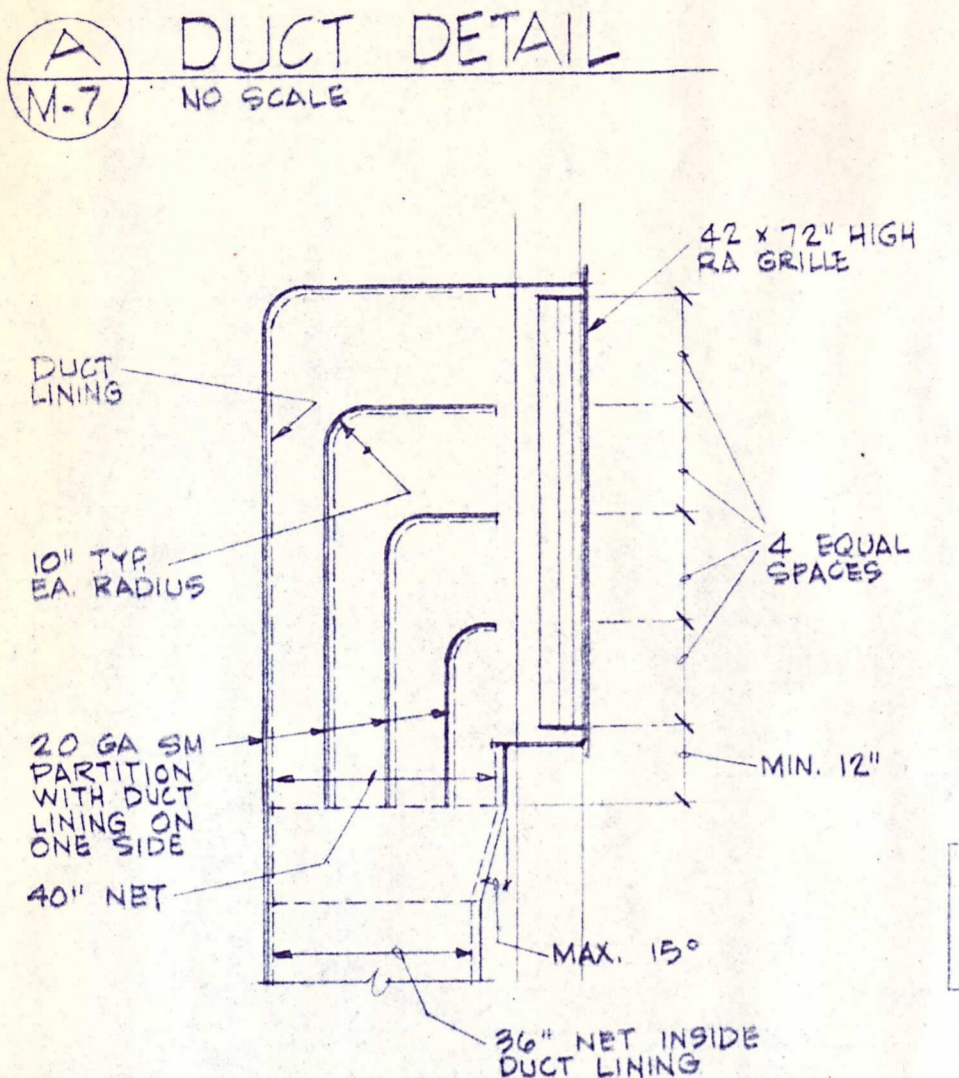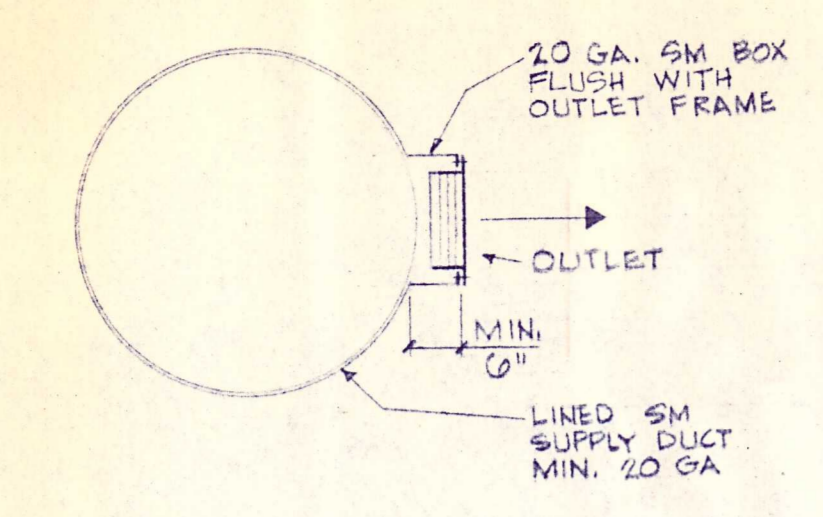


N HVAC - SECOND FLOOR PLAN
 SCALE: 1/8" = 1'-0"

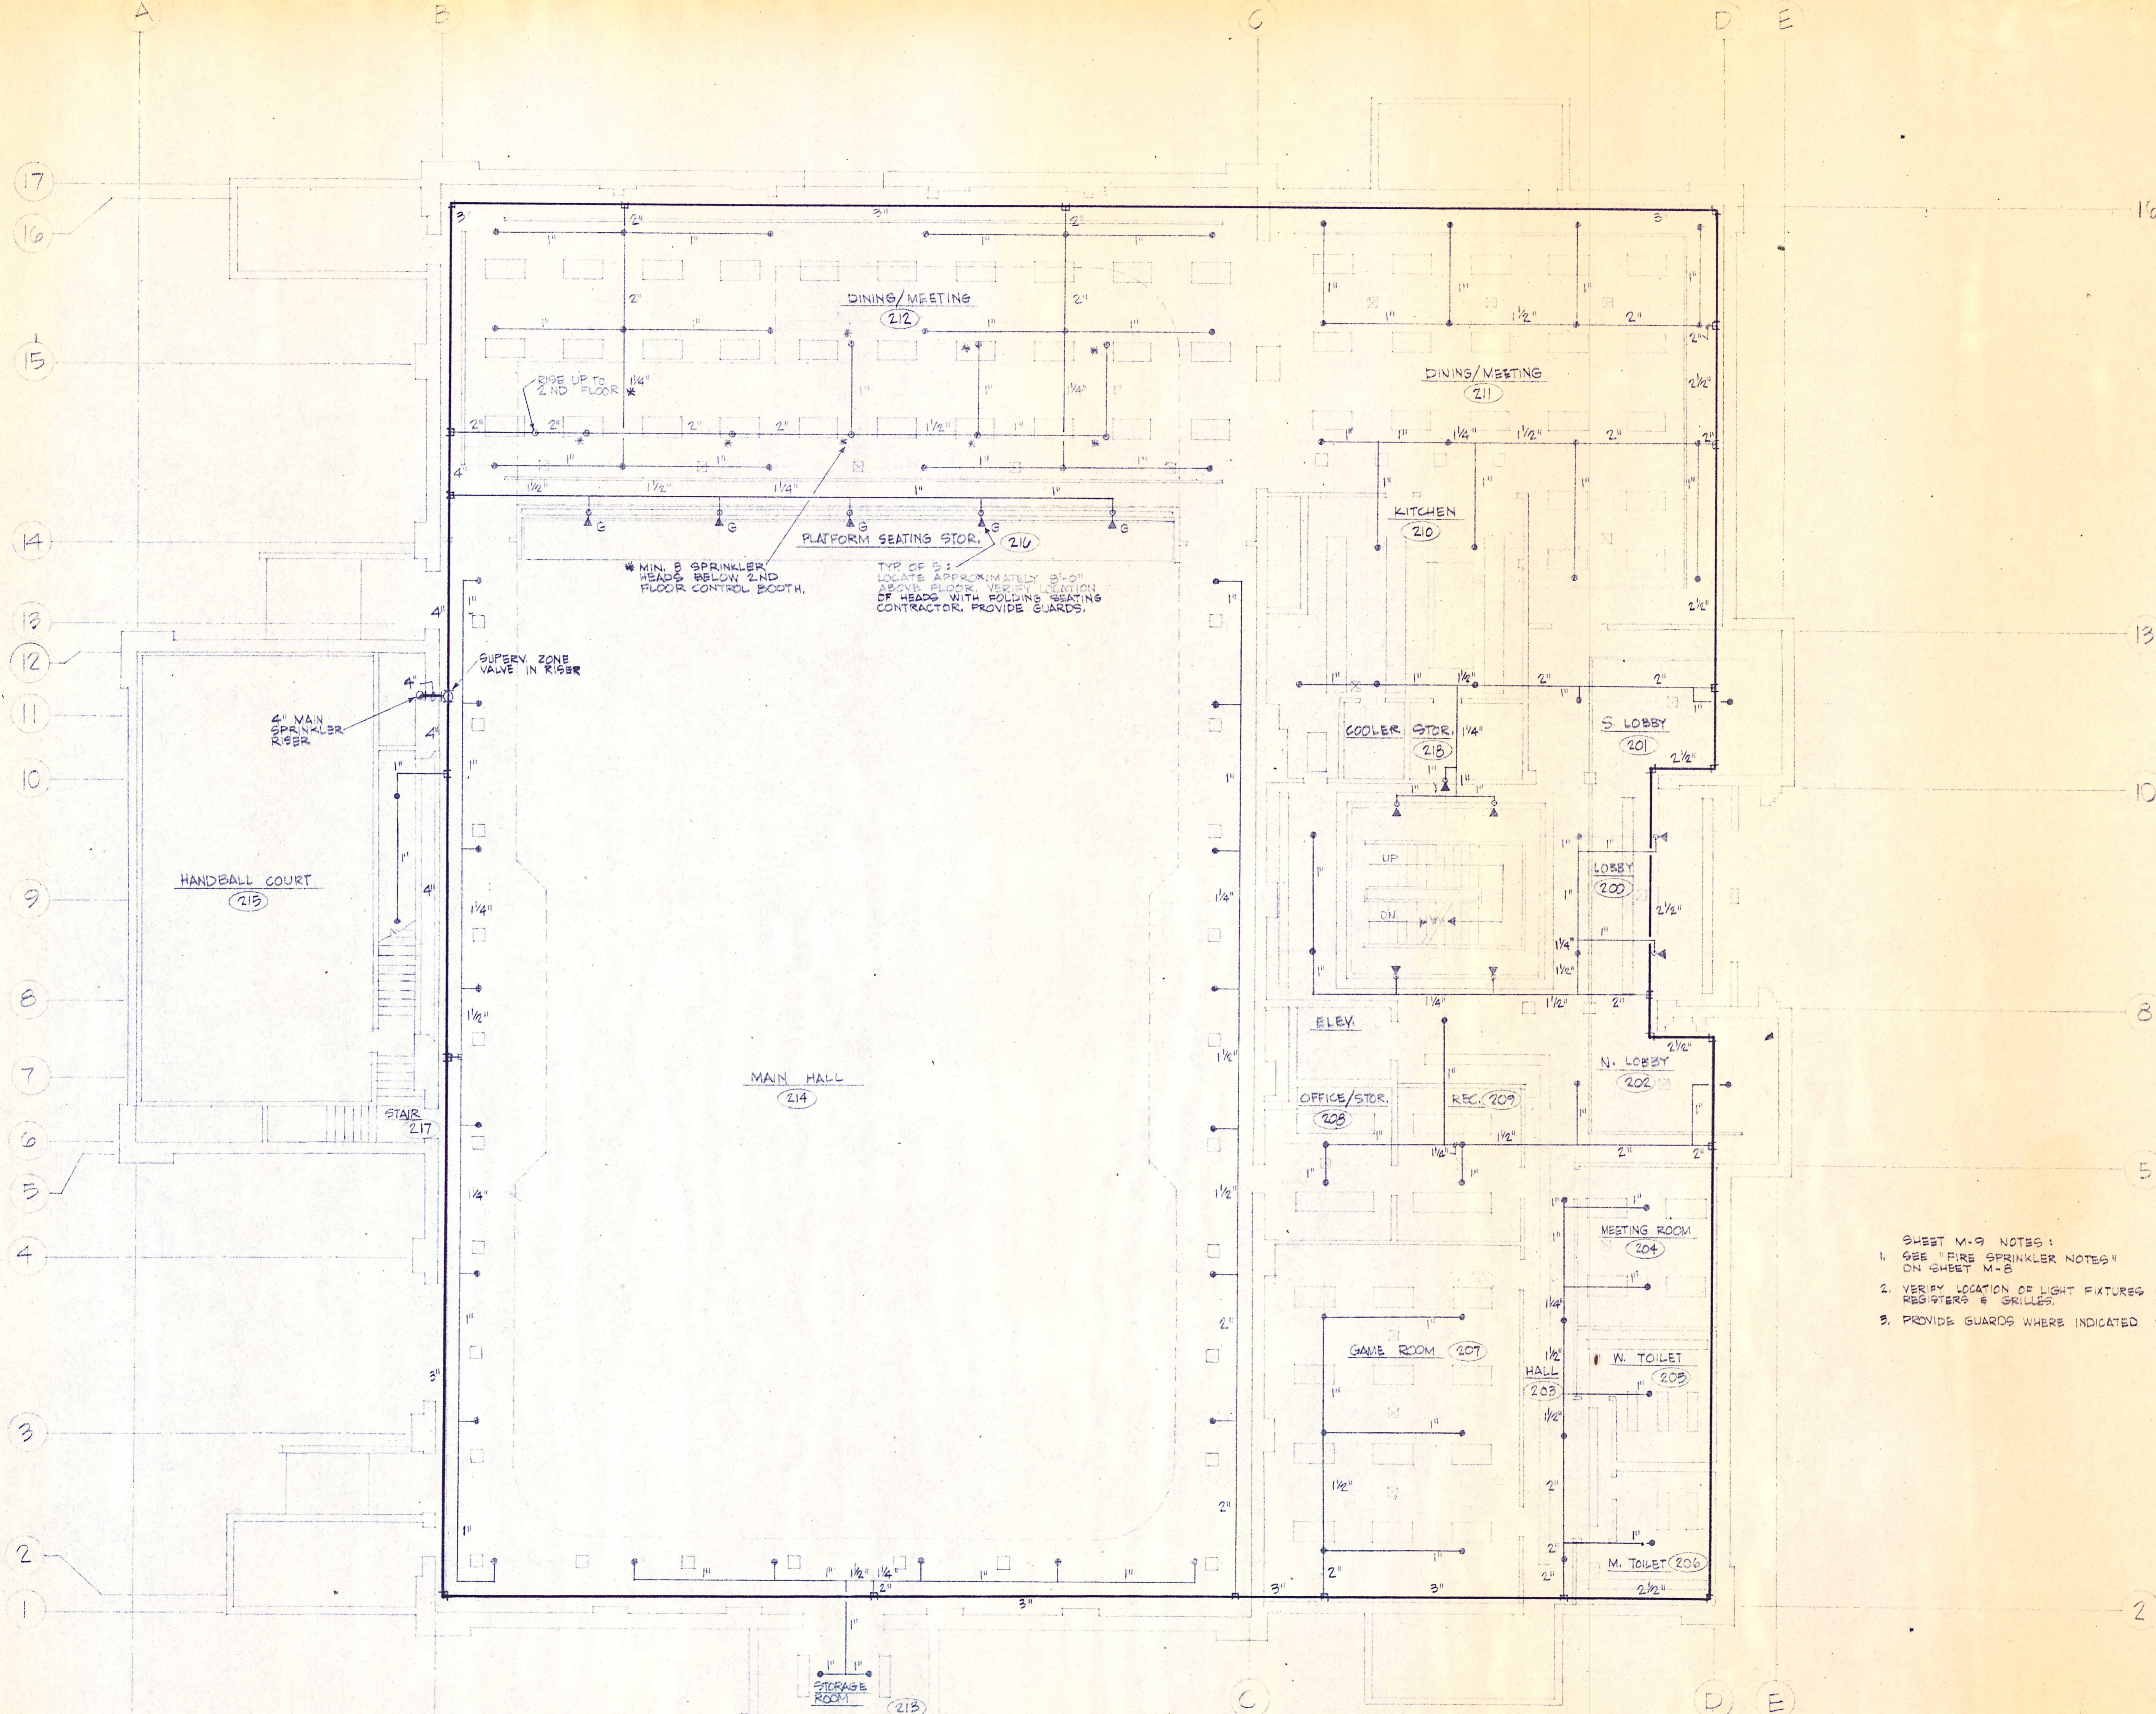

- SHEET M-9 NOTES:
1. SEE "FIRE SPRINKLER NOTES" ON SHEET M-8
 2. VERIFY LOCATION OF LIGHT FIXTURES & CEILING AIR REGISTERS & GRILLES.
 3. PROVIDE GUARDS WHERE INDICATED WITH "G"

SPRINKLER FIRST FLOOR PLAN
 SCALE: 1/8" = 1'-0"

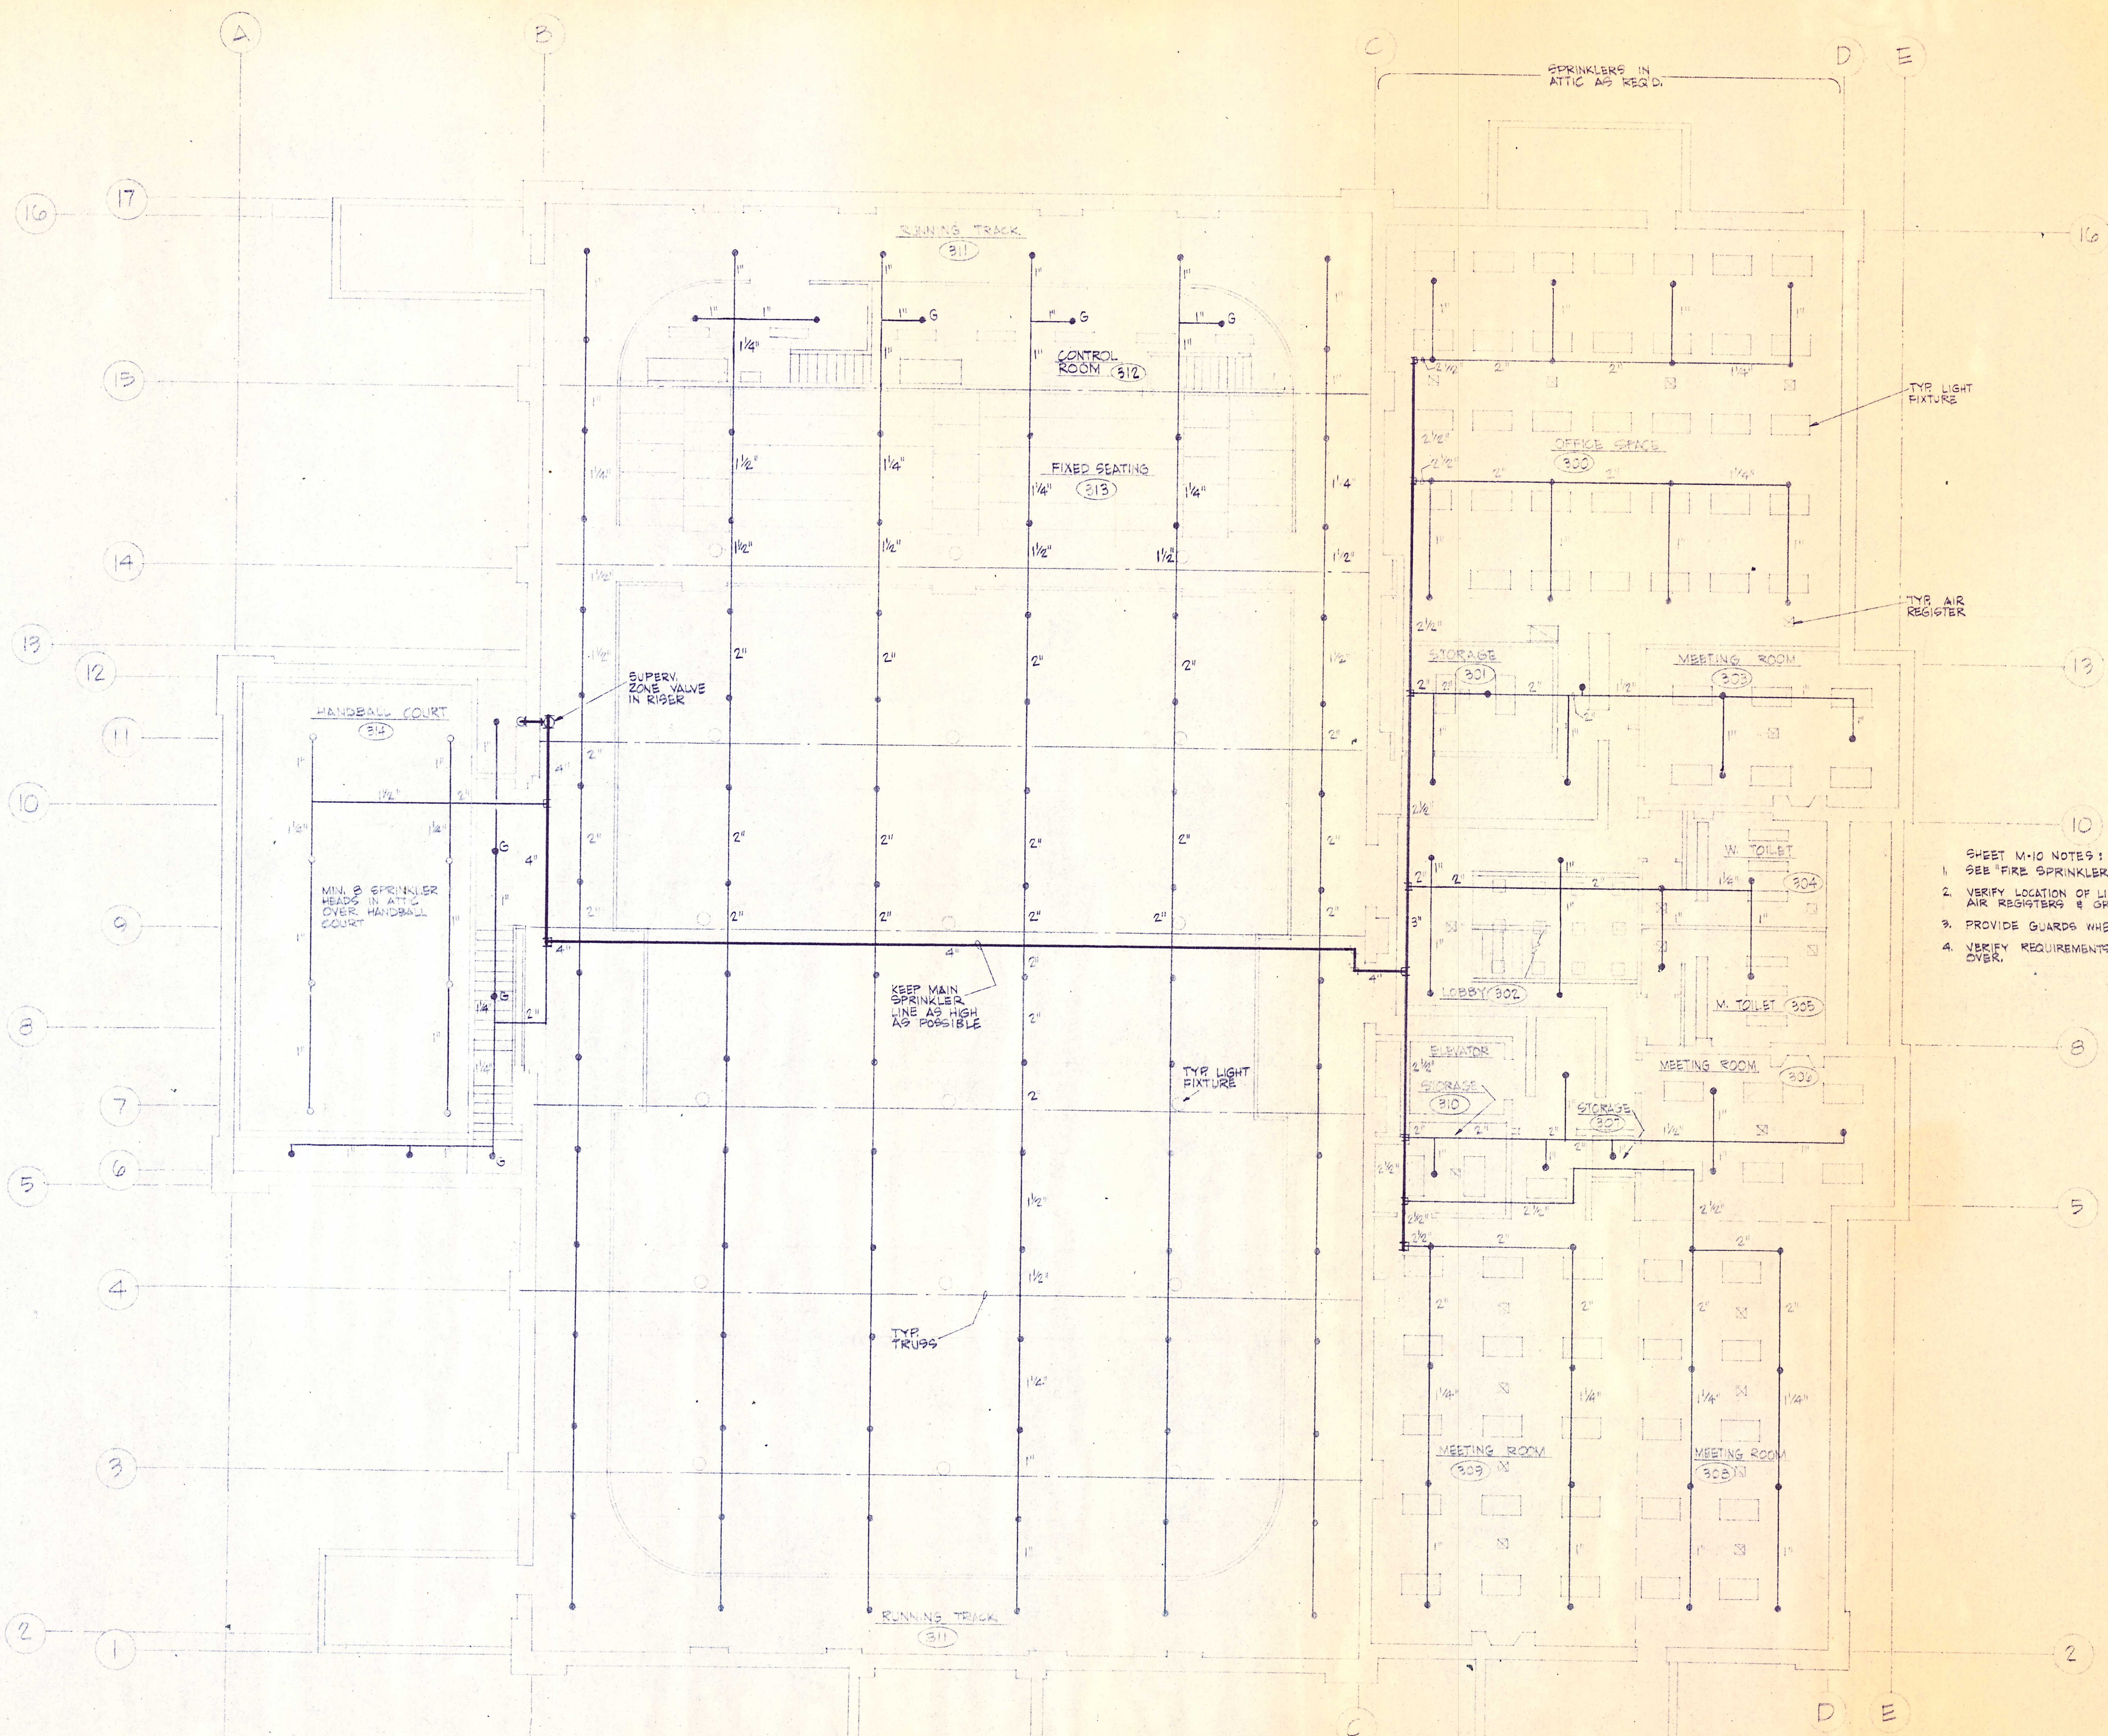

- SHEET M-10 NOTES:
1. SEE "FIRE SPRINKLER NOTES" ON SHEET M-8
 2. VERIFY LOCATION OF LIGHT FIXTURES & CEILING AIR REGISTERS & GRILLES.
 3. PROVIDE GUARDS WHERE INDICATED WITH 'G'
 4. VERIFY REQUIREMENTS OF SPRINKLERS IN ATTIC OVER.

SPRINKLER SECOND FLOOR PLAN
 SCALE: 1/8" = 1'-0"

HARRISON, FUNATAKE,
 MOYSE, ANDREWS, INC.
 CONSULTING ENGINEERS
 2007 S. E. ASH
 PORTLAND, OREGON 97214



WINKLER ASSOCIATES, d/b/a
 ARCHITECTURE, INTERIORS, PLANNING
 1000 SW 10TH AVE. SUITE 200
 PORTLAND, OREGON 97204

McMINNVILLE COMMUNITY CENTER

M
10

